

Drawing name: K:\IND_LEV\170125006_Patch_MCC-600W&500N_McCordsville-IN-2_Design\CADD\PlanSheets\C0.0-TITLE SHEET.dwg C0.0 Jun 03, 2025 2:50pm by: KatePBlack
This document, together with the concepts and designs presented herein, is an instrument of service. It is intended only for the specific purpose and client for which it was prepared. Reuse of and improper reliance on this document without written authorization and adaptation by Kimley-Horn and Associates, Inc. shall be without liability to Kimley-Horn and Associates, Inc.

FINAL ENGINEERING PLANS

GATEWAY AT MCCORDSVILLE

MASS GRADING & PUBLIC INFRASTRUCTURE

NWC OF N 600 W & W 500 N

MCCORDSVILLE, IN 46055


Indiana Utilities Protection Service



UTILITY AND GOVERNING AGENCY CONTACTS				
SERVICE / JURISDICTION	COMPANY / DEPT.	ADDRESS	PHONE NUMBER	CONTACT
SANITARY SEWER	AQUA INDIANA	5750 CASTLE CREEK PKWY N. DR., SUITE 314, INDIANAPOLIS, IN 46250	(317) 577-1390	JIM SHIELDS, P.E.
STORM SEWER	MCCORDSVILLE PUBLIC WORKS	6280 W. 800 N., MCCORDSVILLE, IN 46055	(317) 335-3493	RON CRIDER
WATER	CITIZENS ENERGY GROUP	2150 DR MARTIN LUTHER KING JR ST., INDIANAPOLIS, IN 46202	(317) 927-4351	BRAD HOSTETLER
NATURAL GAS	CENTERPOINT ENERGY	16222 ALLISONVILLE RD., NOBLESVILLE, IN 46060	(317) 260-5477	JAY BOSER
ELECTRICITY	NINE STAR CONNECT	2243 EAST MAIN ST., GREENFIELD, IN 46140	(317) 326-3131	
TELEPHONE / COMMUNICATIONS	NINE STAR CONNECT	2243 EAST MAIN ST., GREENFIELD, IN 46140	(317) 323-2081	JASON WARRICK
STREETS	MCCORDSVILLE PUBLIC WORKS	6280 W. 800 N., MCCORDSVILLE, IN 46055	(317) 335-3493	RON CRIDER
PLANNING AND ZONING	MCCORDSVILLE PLANNING AND BUILDING DEPARTMENT	6280 W. 800 N., MCCORDSVILLE, IN 46055	(317) 355-3604	RYAN CRUM
TOWN ENGINEER	MCCORDSVILLE ENGINEERING DEPARTMENT	6280 W. 800 N., MCCORDSVILLE, IN 46055	(317) 335-3604	MARK WITSMAN

PROJECT TEAM				
ROLE	COMPANY	ADDRESS	PHONE NUMBER	CONTACT
DEVELOPER/OWNER	PATCH DEVELOPMENT	6950 E. 96TH ST., SUITE 200, FISHERS, IN, 46038	(317) 412-4298	ANDREW GREENWOOD
CIVIL ENGINEER	KIMLEY-HORN & ASSOCIATES, INC.	250 E. 96TH ST., SUITE 580, INDIANAPOLIS, IN 46240	(317) 218-9560	NEIL KIPPENBROCK, PE
LAND SURVEYOR	SCHNEIDER GEOMATICS	8901 OTIS AVE., SUITE 100, INDIANAPOLIS, IN 46216	(317) 826-7388	MARK S. HENNESSEY, PS

LEGAL DESCRIPTION
REFER TO C1.1—GENERAL NOTES

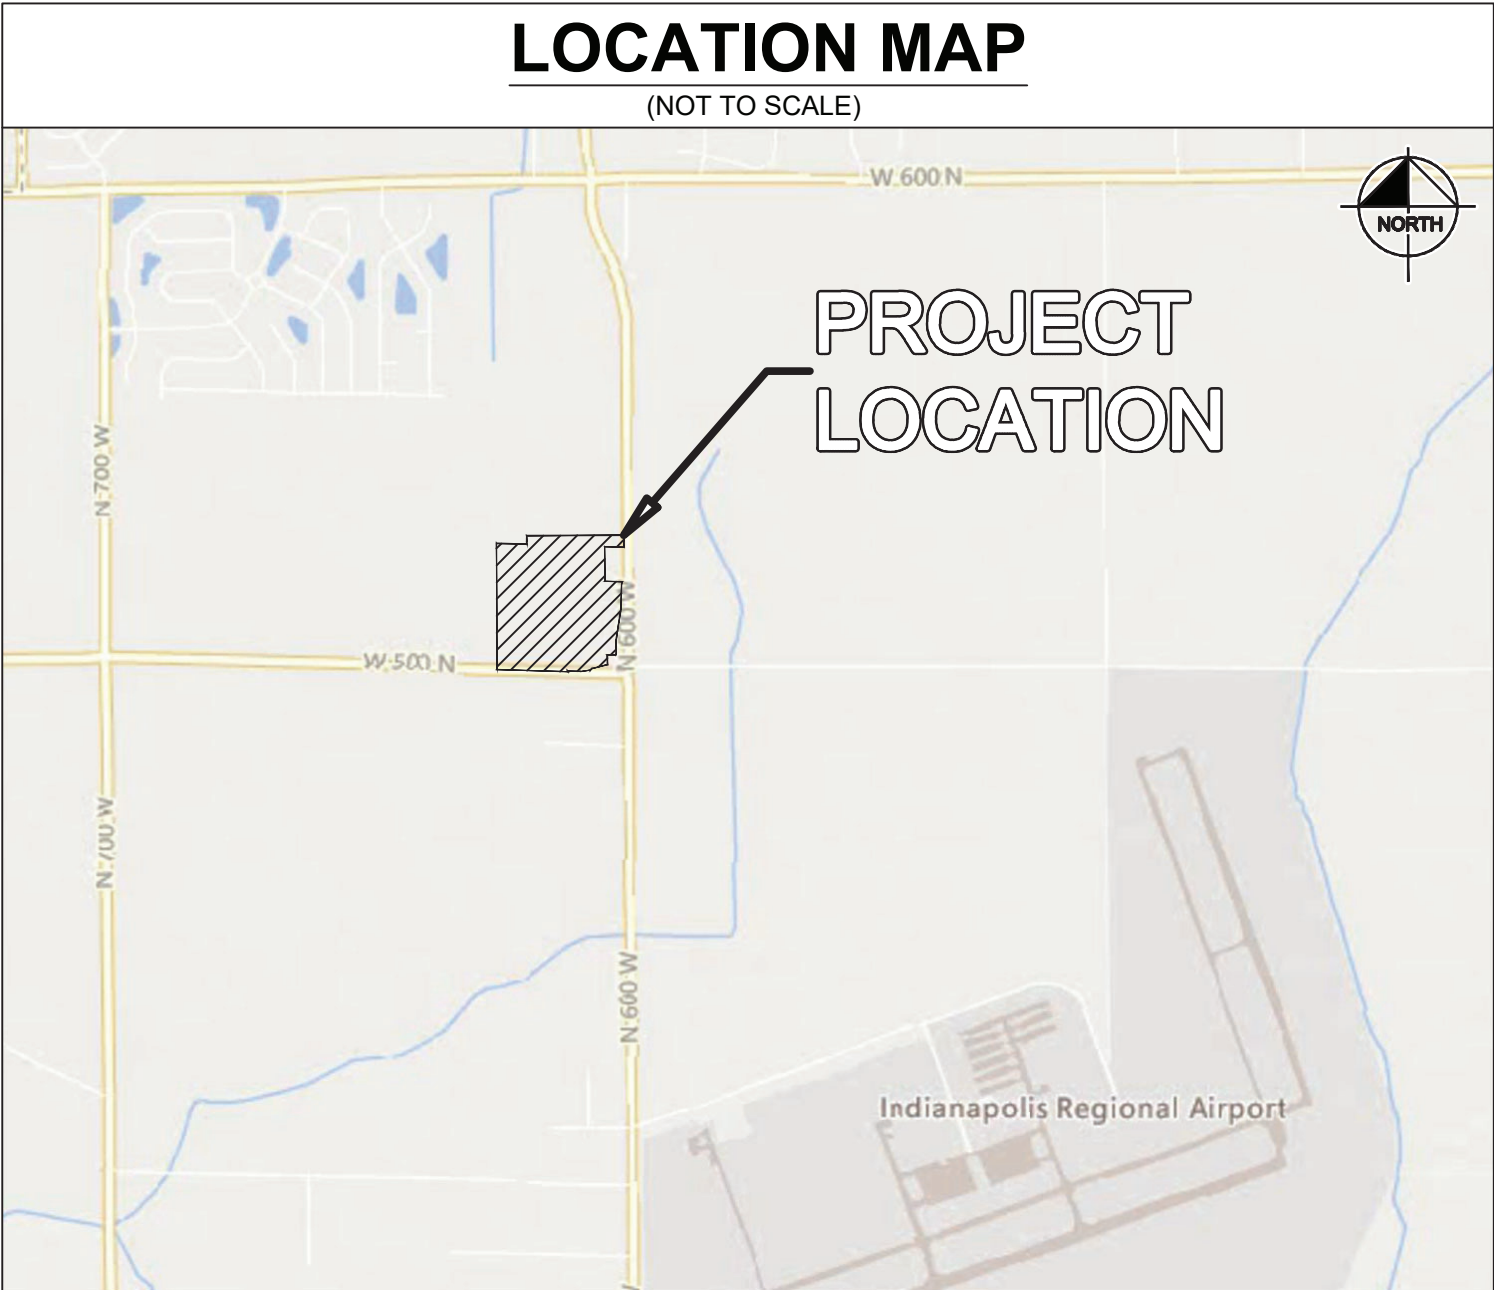

HANCOCK COUNTY
CONSTRUCTION OF INFRASTRUCTURE AND MASS GRADING OF A FUTURE MIXED-USE DEVELOPMENT FOR PATCH DEVELOPMENT ON ± 38.88 AC. PROJECT IS IN SECTION 1 OF T16N, R5E IN THE TOWN OF MCCORDSVILLE, HANCOCK COUNTY, INDIANA

Sheet List Table	
Sheet Number	Sheet Title
C0.0	TITLE SHEET
C1.0	GENERAL SPECIFICATIONS
C1.1	GENERAL NOTES
V1.0	ALTA SURVEY
V1.1	ALTA SURVEY
V1.2	ALTA SURVEY
V1.3	ALTA SURVEY
V1.4	ALTA SURVEY
V1.5	ALTA SURVEY
V1.6	TOPOGRAPHIC SURVEY
V1.7	TOPOGRAPHIC SURVEY
C2.0	OVERALL EXISTING CONDITIONS AND DEMO PLAN
C3.0	OVERALL SITE PLAN
C3.1	OVERALL SITE AERIAL PLAN
C4.0	OVERALL EROSION CONTROL PLAN PHASE 0
C4.1	OVERALL EROSION CONTROL PLAN PHASE 1
C4.3	EROSION CONTROL DETAILS
C4.4	SWPPP
C5.0	OVERALL GRADING AND DRAINAGE PLAN PHASE 1
C5.1	GRADING AND DRAINAGE PLAN PHASE 1
C5.2	GRADING AND DRAINAGE PLAN PHASE 1
C5.3	GRADING AND DRAINAGE PLAN PHASE 1
C5.4	GRADING AND DRAINAGE PLAN PHASE 1
C5.5	OVERALL GRADING AND DRAINAGE PLAN PHASE 2
C6.0	OVERALL SEWER PLAN
C6.1	SANITARY SEWER PLAN & PROFILE
C6.2	SANITARY SEWER PLAN & PROFILE
C6.3	SANITARY SEWER PLAN & PROFILE
C6.4	OVERALL WATER PLAN
C6.5	WATER PLAN AND PROFILE
C6.6	WATER PLAN AND PROFILE
C6.7	WATER PLAN AND PROFILE
C6.8	WATER PLAN AND PROFILE
C6.9	OVERALL STORM PLAN
C6.10	STORM PROFILES
C6.11	STORM PROFILES
C6.12	STORM PROFILES
C6.13	STRUCTURE DATA TABLE
C7.0	CONSTRUCTION DETAILS
C7.1	CONSTRUCTION DETAILS
C7.2	CONSTRUCTION DETAILS
C7.3	CONSTRUCTION DETAILS
C7.4	CONSTRUCTION DETAILS
R1.0	TYPICAL SECTIONS
R2.0	ALIGNMENT DATA
R3.0	ROADWAY PLAN AND PROFILE
R3.1	ROADWAY PLAN AND PROFILE
R3.2	ROADWAY PLAN AND PROFILE
R3.3	ROADWAY PLAN AND PROFILE
R3.4	ROADWAY PLAN AND PROFILE
R4.0	MAINTENANCE OF TRAFFIC PLAN
R4.1	MAINTENANCE OF TRAFFIC PLAN - SEWER TRENCHING
R5.0	SIGNING AND MARKING PLAN
L1.0	CONCEPTUAL LANDSCAPE PLAN
P1.0	CONCEPTUAL PHOTOMETRIC PLAN
1-20	AQUA INDIANA STANDARDS

National Flood Hazard Layer FIRMette



TAC COMMENTS

06/03/25

TNH

AS NOTED

DESIGNED BY: DJZ

DRAWN BY: DJZ

CHECKED BY: NPK

Kimley»Horn

© 2025 KIMLEY-HORN AND ASSOCIATES, INC.
500 EAST 96TH STREET, SUITE 300,
INDIANAPOLIS, IN 46240
WWW.KIMLEY-HORN.COM

NEIL KIPPENBROCK

REGISTERED PROFESSIONAL ENGINEER

NOT APPROVED FOR CONSTRUCTION

Neil Kippenbrock

PATCH

DEVELOPMENT

GATEWAY AT MCCORDSVILLE

MASS GRADING & PUBLIC INFRASTRUCTURE

NWC OF N 600 W & W 500 N, MCCORDSVILLE, IN 46055

ORIGINAL ISSUE:

05/02/2025

KHA PROJECT NO. 170125008

SHEET NUMBER

C0.0



Indiana Utilities Protection Service

Call 811
before you dig

GRAPHIC SCALE IN FEET
0 40 80 160

Call 811
before you dig

PAVING LEGEND

RIGHT OF WAY PAVEMENT
SEE SHEET R1.0 - TYPICAL SECTIONS FOR PAVEMENT SECTION

W CR 500 N PAVEMENT (LOCAL COLLECTOR ROAD)
SEE TOWN OF MCCORDSVILLE STANDARD DETAILS SHEET 2 FOR PAVEMENT SECTION

N CR 600 W PAVEMENT (COLLECTOR ROAD)
SEE TOWN OF MCCORDSVILLE STANDARD DETAILS SHEET 2 FOR PAVEMENT SECTION

CONCRETE SIDEWALK
SEE SHEET R1.0 - TYPICAL SECTIONS FOR PAVEMENT SECTION

MULTI-USE PATH
SEE TOWN OF MCCORDSVILLE STANDARD DETAILS SHEET 2 FOR PAVEMENT SECTION

SITE SUMMARY

SITE ZONING = PUD

SITE ACREAGE = 38.88 AC.±

BENCHMARKS

SITE BENCHMARKS:
(LOCATIONS SHOWN ON SURVEY)

CP 100 - CAPPED REBAR
N: 1678484.595
E: 255521.232
ELEVATION=861.621

CP 105 - CAPPED REBAR
N: 1679739.088
E: 258192.207
ELEVATION=862.312

EXISTING LEGEND

BOLLARD
CONTROL BENCHMARK
ROW MONUMENT
FLAG POLE
MAIL BOX
UTILITY POLE
POST
SOIL BORING
HANDICAP SYMBOL
SIGN
CABLE MANHOLE
CABLE PEDESTAL
TELEPHONE PEDESTAL
TELEPHONE HAND HOLE
TELEPHONE MARKER
TELEPHONE MANHOLE
FIBER OPTIC MAKER
SWALE
FENCE LINE
SANITARY SEWER
STORM DRAIN
WATER LINE
TREE LINE

MISC LID
MONITOR WELL
GAS MARKER
GAS METER
GAS VALVE
AC UNIT
AREA LIGHT
ELECTRICAL BOX
ELECTRICAL HAND HOLE
ELECTRICAL METER
ELECTRICAL MANHOLE
ELECTRICAL MARKER
ELECTRICAL TRANSFORMER
GUY POLE/WIRE
POWER POLE
TRAFFIC SIGNAL POLE
TRAFFIC MANHOLE

YARD LIGHT
SANITARY CLEANOUT
SANITARY MANHOLE
VENT PIPE
STORM CURB INLET
STORM INLET
STORM ROOF DRAIN
STORM DRAIN MANHOLE
STORM YARD DRAIN
FIRE DEPT CONNECTION
FIRE HYDRANT
IRRIGATION VALVE
POST INDICATOR VALVE
WELL
WATER METER
WATER VALVE
TREE / STUMP
TOE OF SLOPE
TOP OF BANK
UNDERGROUND FIBER OPTIC
OVERHEAD ELECTRICAL
UNDERGROUND GAS
UNDERGROUND TELEPHONE

GENERAL PLAN NOTES

REFER TO GENERAL NOTES SHEET FOR MORE INFORMATION INCLUDING THE FOLLOWING: (EXISTING LEGEND, BENCHMARK INFORMATION, AND SPECIFIC GENERAL PLAN NOTES.)

TAC COMMENTS

AS NOTED

DESIGNED BY DJZ

DRAWN BY: DJZ

CHECKED BY: NPK

SCALE:

NEIL KIPPENBERG
REGISTERED PROFESSIONAL ENGINEER
NOT APPROVED FOR CONSTRUCTION

PATCH
DEVELOPMENT

OVERALL SITE AERIAL PLAN

GATEWAY AT MCCORDSVILLE
MASS GRADING & PUBLIC INFRASTRUCTURE
NWC OF N 600 W & W 500 N,
MCCORDSVILLE, IN 46055


ORIGINAL ISSUE:
05/02/2025

KHA PROJECT NO.
170125008

SHEET NUMBER

C3.1

Drawing name: K:\IND\DEV\170125008_Patch_MCCORDSVILLE_IN2_Design\CADD\PlanSheets\C5.0-OVERALL GRADING AND DRAINAGE PLAN.dwg C5.0 Jun 03, 2025 2:51pm by KatePacak
This document, together with the concepts and designs presented herein, as an instrument of service, is intended only for the specific purpose and client for which it was prepared. Reuse of and improper reliance on this document without written authorization and adaptation by Kimley-Horn and Associates, Inc. shall be without liability to Kimley-Horn and Associates, Inc.

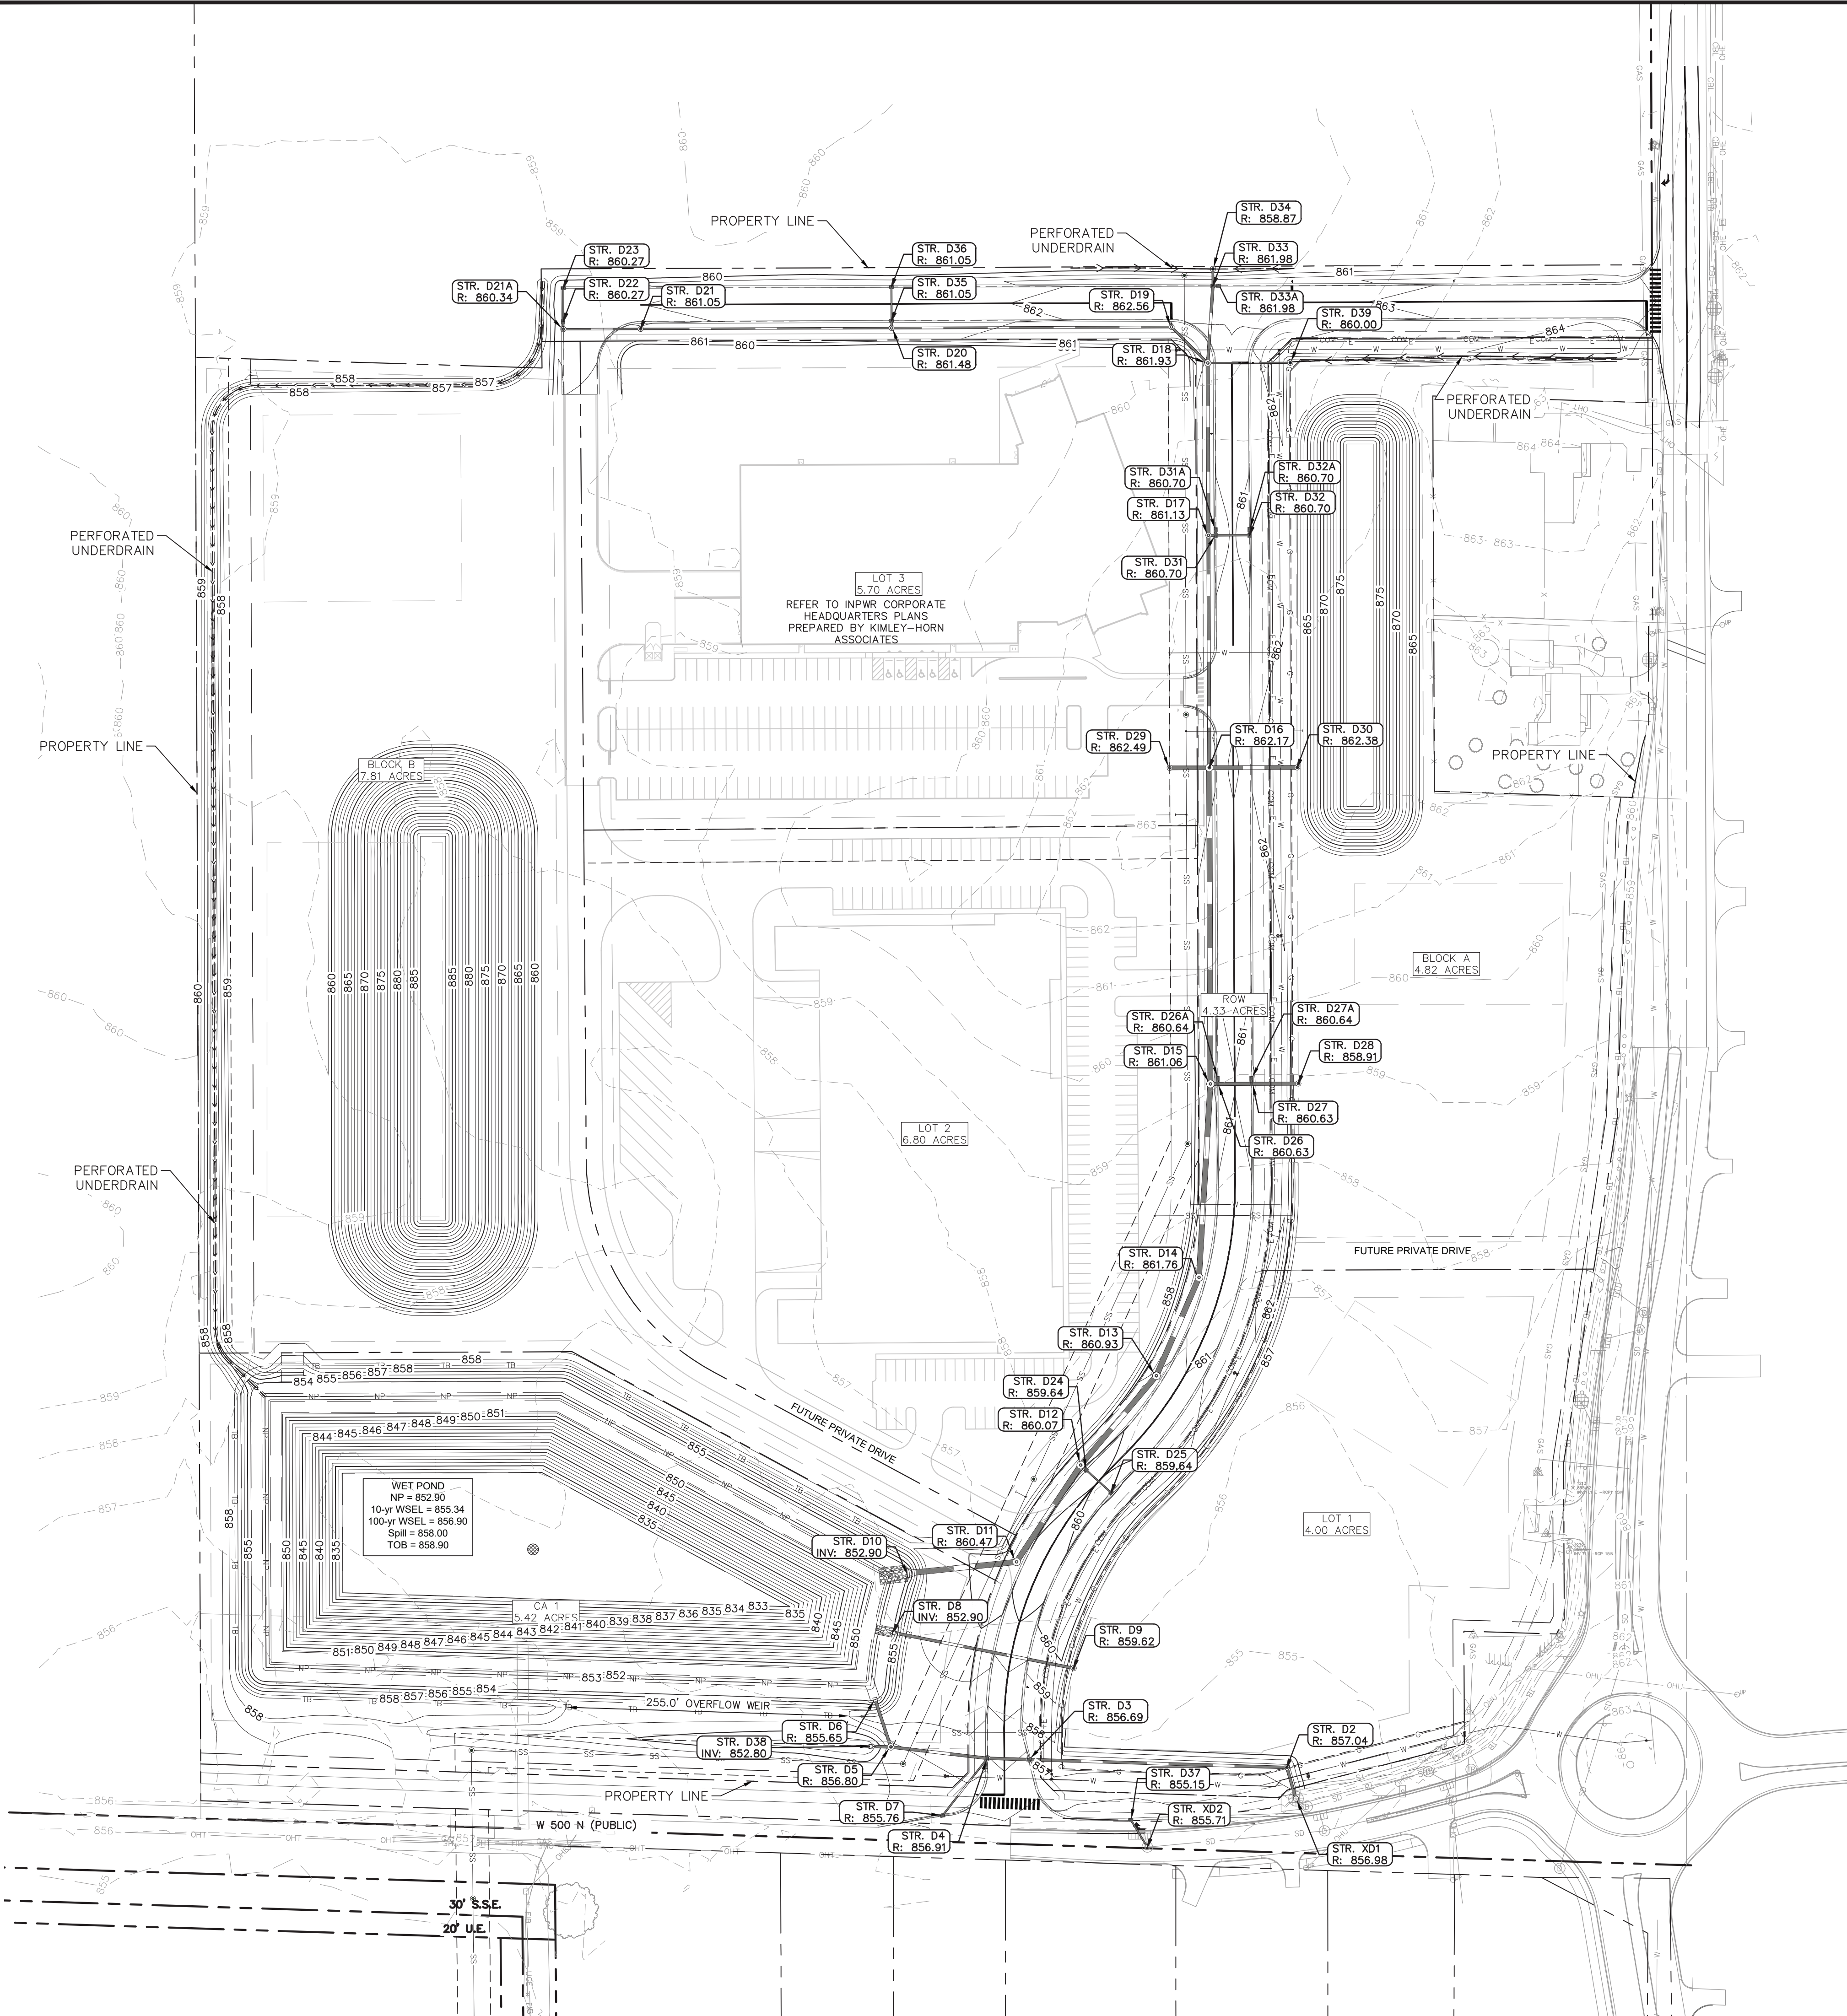

Indiana Utilities Protection Service

Call 811

before you dig

NORTH

GRAPHIC SCALE IN FEET
0 40' 80' 160'


EXISTING LEGEND		

GRADING LEGEND	
	FINISHED GRADE SPOT ELEVATION
	TOP OF CURB / BOTTOM OF CURB SPOT ELEVATION
	FLOW LINE SPOT ELEVATION
	MATCH EXISTING SPOT ELEVATION
	FINISHED FLOOR SPOT ELEVATION
	FINISHED GRADE NEAR BUILDING SPOT ELEVATION
	TOP OF WALL SPOT ELEVATION
	BOTTOM OF WALL SPOT ELEVATION
	RIM ELEVATION
	STRUCTURE ID & RIM ELEVATION
	STRUCTURE ID & INVERT ELEVATION
	PROPOSED CONTOUR
	RIDGE LINE
	SLOPE AND FLOW DIRECTION
	100-YEAR OVERLAND OVERFLOW ROUTE
	DETENTION BASIN 100-YEAR EMERGENCY
	PROPOSED SWALE
	PROPOSED STORM SEWER
	PROPOSED STORM STRUCTURES
	PROPOSED SANITARY MANHOLE
	PROPOSED STORM/SANITARY CLEANOUT
	PROPOSED WATER STRUCTURES
	PROPOSED LIGHT POLES
	PROPOSED TRANSFORMER PAD

- ### GRADING NOTES
- CONTRACTOR TO VERIFY ALL EXISTING TOPOGRAPHY AND STRUCTURES ON THE SITE AND IMMEDIATELY NOTIFY THE ENGINEER OF ANY DISCREPANCIES PRIOR TO STARTING WORK.
 - ALL PAVEMENT SPOT GRADE ELEVATIONS AND RIM ELEVATIONS WITHIN OR ALONG CURB AND GUTTER REFER TO EDGE OF PAVEMENT ELEVATIONS UNLESS OTHERWISE NOTED.
 - ALL ELEVATIONS SHOWN DEPICT FINISHED GRADE OR EDGE OF PAVEMENT UNLESS OTHERWISE NOTED. GENERAL CONTRACTOR TO COORDINATE WITH EXCAVATION, LANDSCAPE AND PAVING SUBCONTRACTORS REGARDING TOPSOIL THICKNESS FOR LANDSCAPE AREAS AND PAVEMENT SECTION THICKNESS FOR PAVED AREAS TO PROPERLY ENSURE ADEQUATE CUT TO ESTABLISH SUBGRADE ELEVATIONS.
 - NO EARTHEN SLOPE SHALL BE GREATER THAN 3:1, UNLESS OTHERWISE NOTED.
 - MAXIMUM SLOPE IN ACCESSIBLE PARKING SPACES AND LOADING ZONES SHALL NOT EXCEED 2.0% IN ALL DIRECTIONS.
 - MAXIMUM RUNNING SLOPE SHALL NOT EXCEED 5% AND CROSS SLOPE SHALL NOT EXCEED 2% ON ALL SIDEWALKS AND ACCESSIBLE ROUTES UNLESS OTHERWISE NOTED.
 - WHEN NATURAL FLOW OF DRAINAGE IS AWAY FROM CURB, CONTRACTOR TO INSTALL REVERSE GUTTER PITCH.
 - MATCH EXISTING ELEVATIONS AT THE PROPERTY LIMITS.
 - ALL STOOPS OR PEDESTRIAN EGRESS POINTS FROM THE BUILDING(S) SHALL BE NO GREATER THAN 2% FOR THE FIRST 5'.


BENCHMARKS	
SITE BENCHMARKS: (LOCATIONS SHOWN ON SURVEY)	
CP 100 - CAPPED REBAR	
N: 1678484.595	
E: 255521.232	
ELEVATION=861.621	
CP 105 - CAPPED REBAR	
N: 1679739.088	
E: 258192.207	
ELEVATION=862.312	

TAC COMMENTS	TNH	06/03/25	DATE	BY
AS NOTED	DESIGNED BY: DJZ	DRAWN BY: DJZ	CHECKED BY: NPK	
SCALE:	NEIL KIPPENBERG REGISTERED PROFESSIONAL ENGINEER NOT APPROVED FOR CONSTRUCTION INDIANA			
OVERALL GRADING AND DRAINAGE PLAN PHASE 1				
GATEWAY AT MCCORDSVILLE MASS GRADING & PUBLIC INFRASTRUCTURE NWC OF N 600 W & W 500 N, MCCORDSVILLE, IN 46055				
ORIGINAL ISSUE: 05/02/2025 KHA PROJECT NO. 170125008 SHEET NUMBER C5.0				

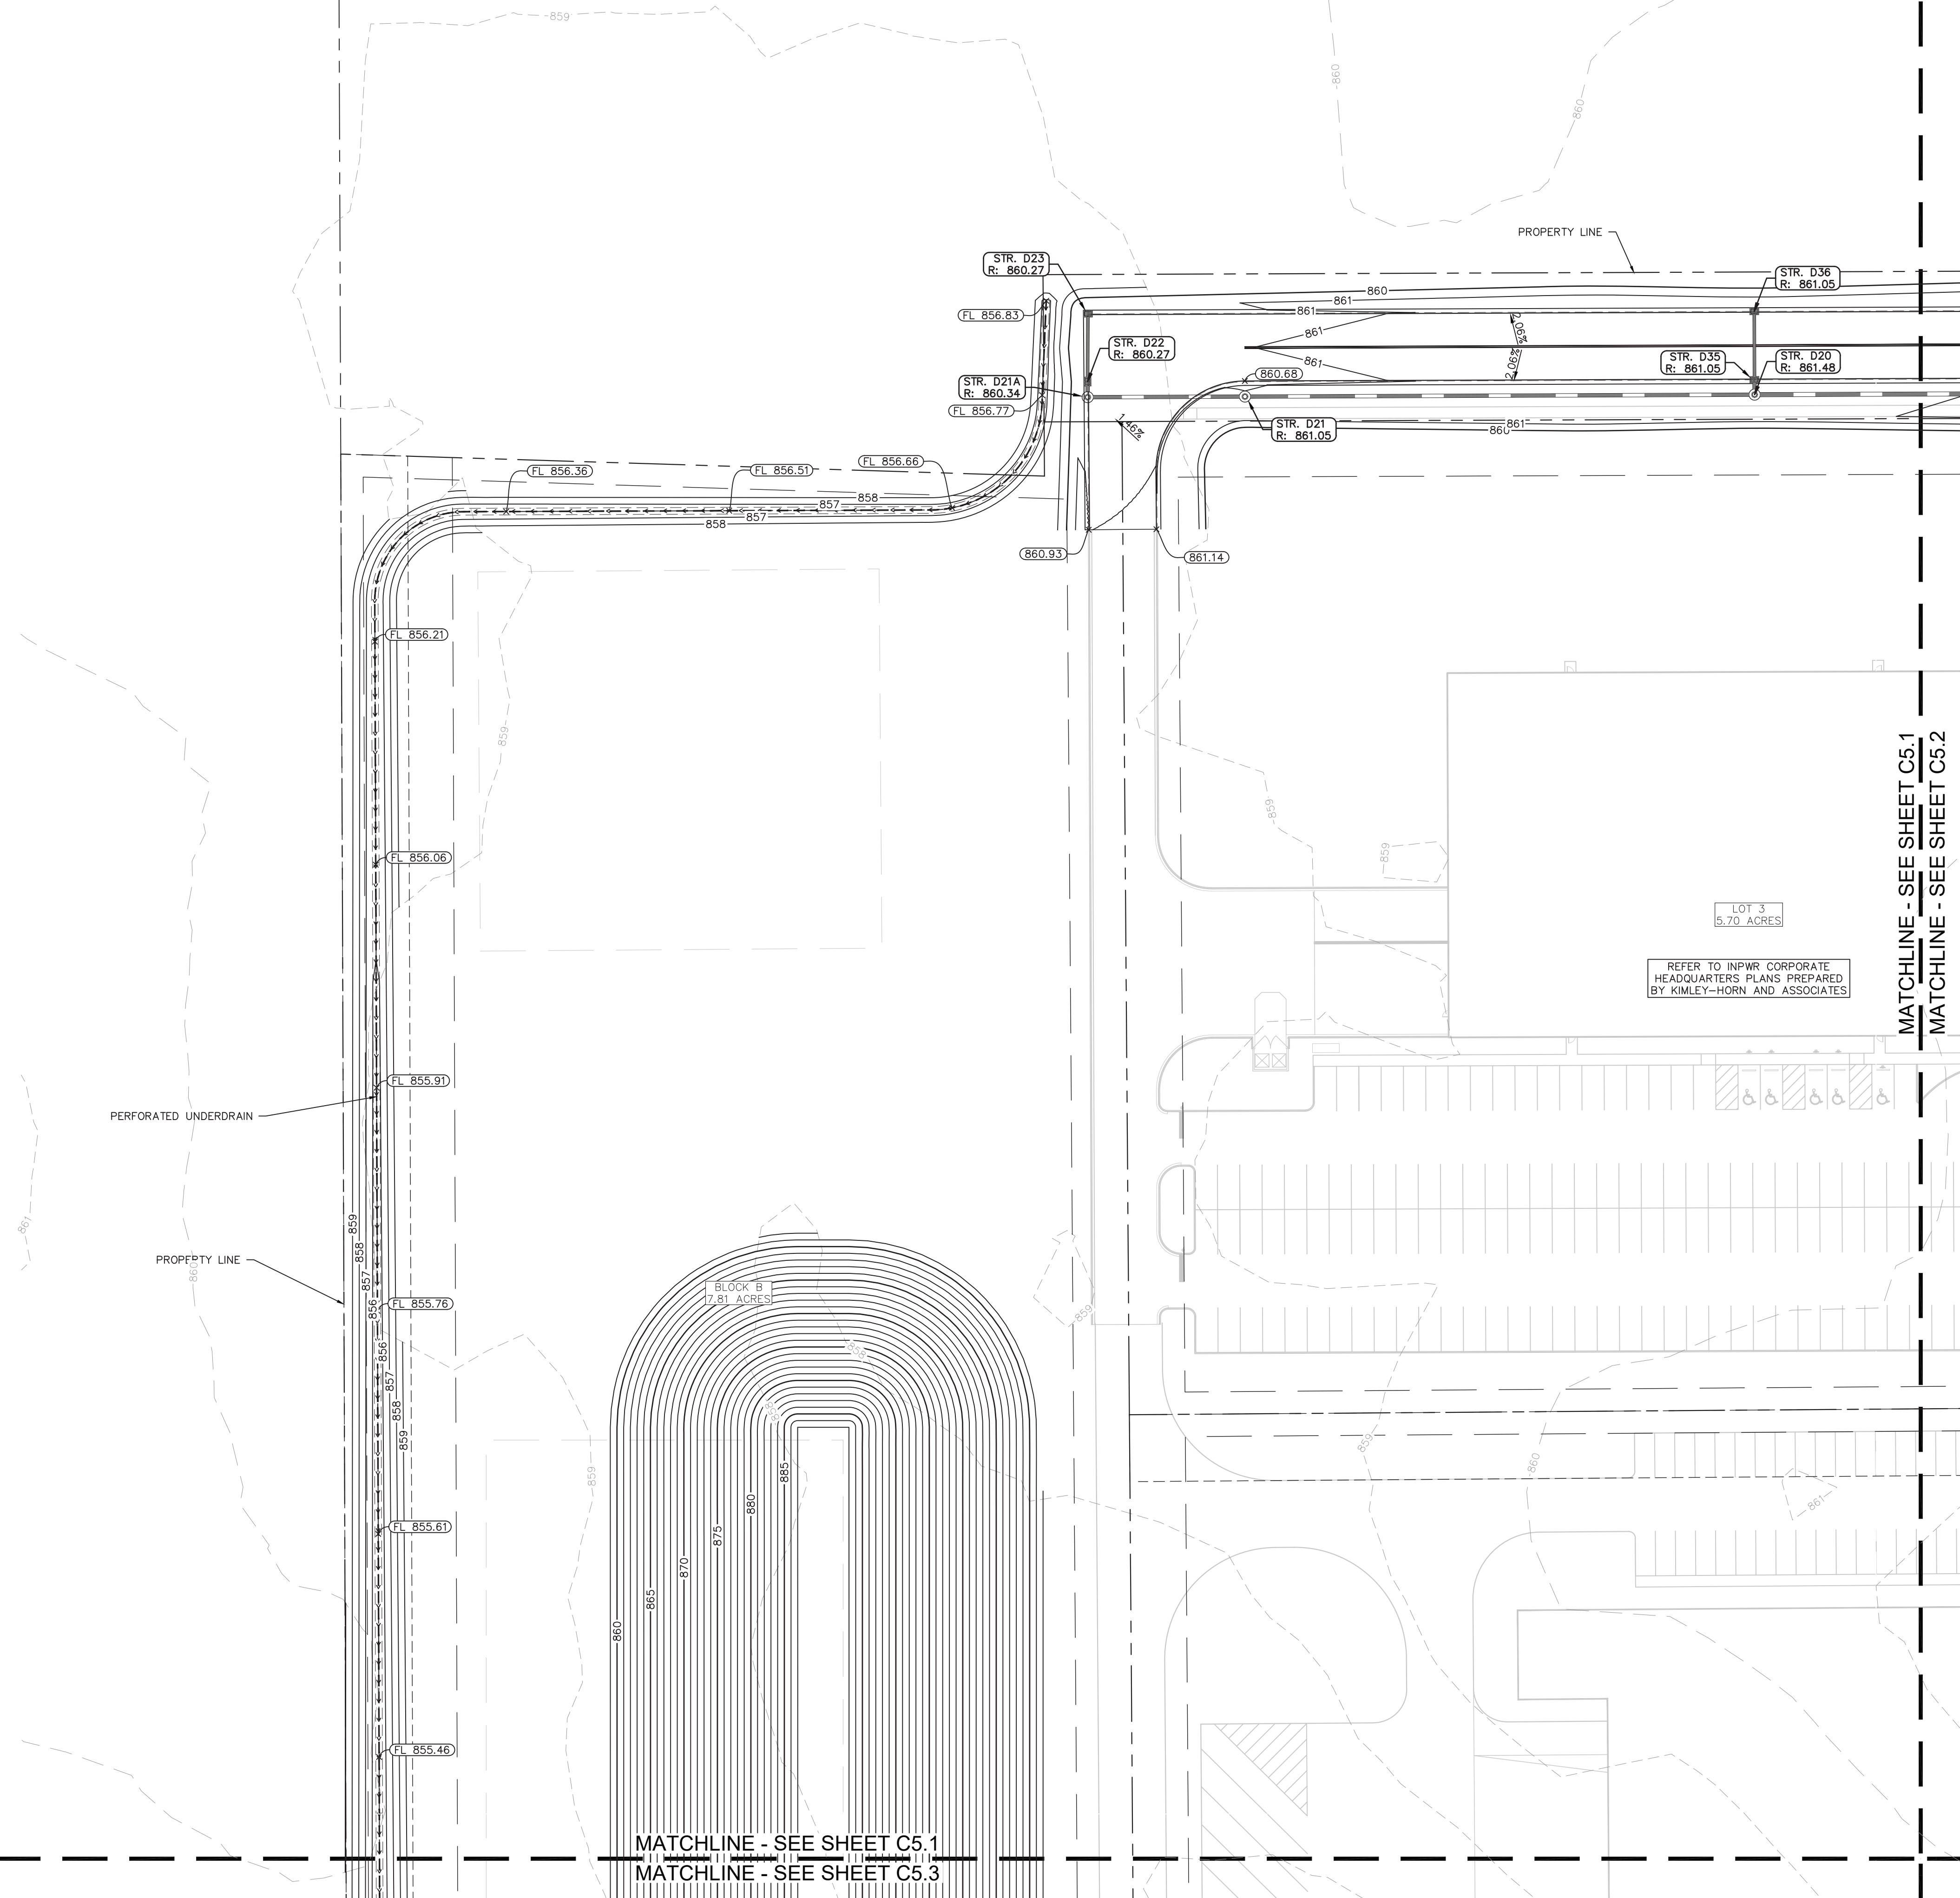

Indiana Utilities Protection Service

Call 811
before you dig

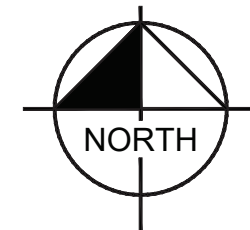

GRAPHIC SCALE IN FEET

0 20' 40' 80'

A horizontal scale bar with alternating black and white segments. The segments are labeled 0, 20', 40', and 80' at the top. The bar is divided into four equal segments, each representing 20 feet. The first segment is white, the second is black, the third is white, and the fourth is black. The total length of the bar is 80 feet.

GRADING LEGEND

	FINISHED GRADE SPOT ELEVATION
	TOP OF CURB / BOTTOM OF STORM SPOT ELEVATION
	FLOW LINE SPOT ELEVATION
	MATCH EXISTING SPOT ELEVATION
	FINISHED FLOOR SPOT ELEVATION
	FINISHED GRADE NEAR BUILDING SPOT ELEVATION
	TOP OF WALL SPOT ELEVATION
	BOTTOM OF WALL SPOT ELEVATION
	RIM ELEVATION
	STRUCTURE ID & RIM ELEVATION
	STRUCTURE ID & INVERT ELEVATION
	PROPOSED CONTOUR
	RIDGE LINE
	SLOPE AND FLOW DIRECTION
	100-YEAR OVERLAND OVERFLOW ROUTE
	DETENTION BASIN 100-YEAR EMERGENCY
	PROPOSED SWALE
	PROPOSED STORM SEWER
	PROPOSED STORM STRUCTURES
	PROPOSED SANITARY MANHOLE
	PROPOSED STORM/SANITARY CLEANOUT
	PROPOSED WATER STRUCTURES
	PROPOSED LIGHT POLES
	PROPOSED TRANSFORMER PAD

MATCHLINE - SEE SHEET C5.1
MATCHLINE - SEE SHEET C5.2

GENERAL PLAN NOTES


REFER TO GENERAL NOTES SHEET FOR MORE INFORMATION INCLUDING THE FOLLOWING: (EXISTING LEGEND, BENCHMARK INFORMATION, AND SPECIFIC GENERAL PLAN NOTES.)

GATEWAY AT MCCORDSVILLE MASS GRADING & PUBLIC INFRASTRUCTURE NWC OF N 600 W & W 500 N, MCCORDSVILLE, IN 46055		GRADING AND DRAINAGE PLAN PHASE 1						<i>Neil Rippner</i>		Kimley»Horn ©2025 KIMLEY-HORN AND ASSOCIATES, INC. 500 EAST 98TH STREET, SUITE 300, INDIANAPOLIS, IN 46240 PHONE: 317-271-4500 WWW.KIMLEY-HORN.COM		SCALE: AS NOTED DESIGNED BY: DJZ DRAWN BY: DJZ CHECKED BY: NPK		△ TAC COMMENTS		06/03/25 TNH	
---	--	---	--	---	--	---	--	----------------------------	--	---	--	---	--	------------------------------	--	----------------------------	--

Drawing name: K:\IND\DEV\170125008_Patch\IND-600W&500N_McCordsville\IN 2 Design\CADD\PlanSheets\C5.1-GRADING AND DRAINAGE PLAN.dwg C5.2 Jun 03, 2023 2:52pm by Kate Polack
This document, together with the concepts and designs presented herein, as an instrument of service, is intended only for the specific purpose and client for which it was prepared. Reuse of and improper reliance on this document without written authorization and adaptation by Kimley-Horn and Associates, Inc. shall be without liability to Kimley-Horn and Associates, Inc.

MATCHLINE - SEE SHEET C5.1
MATCHLINE - SEE SHEET C5.2

REFER TO INPWR CORPORATE
HEADQUARTERS PLANS PREPARED
BY KIMLEY-HORN AND ASSOCIATES

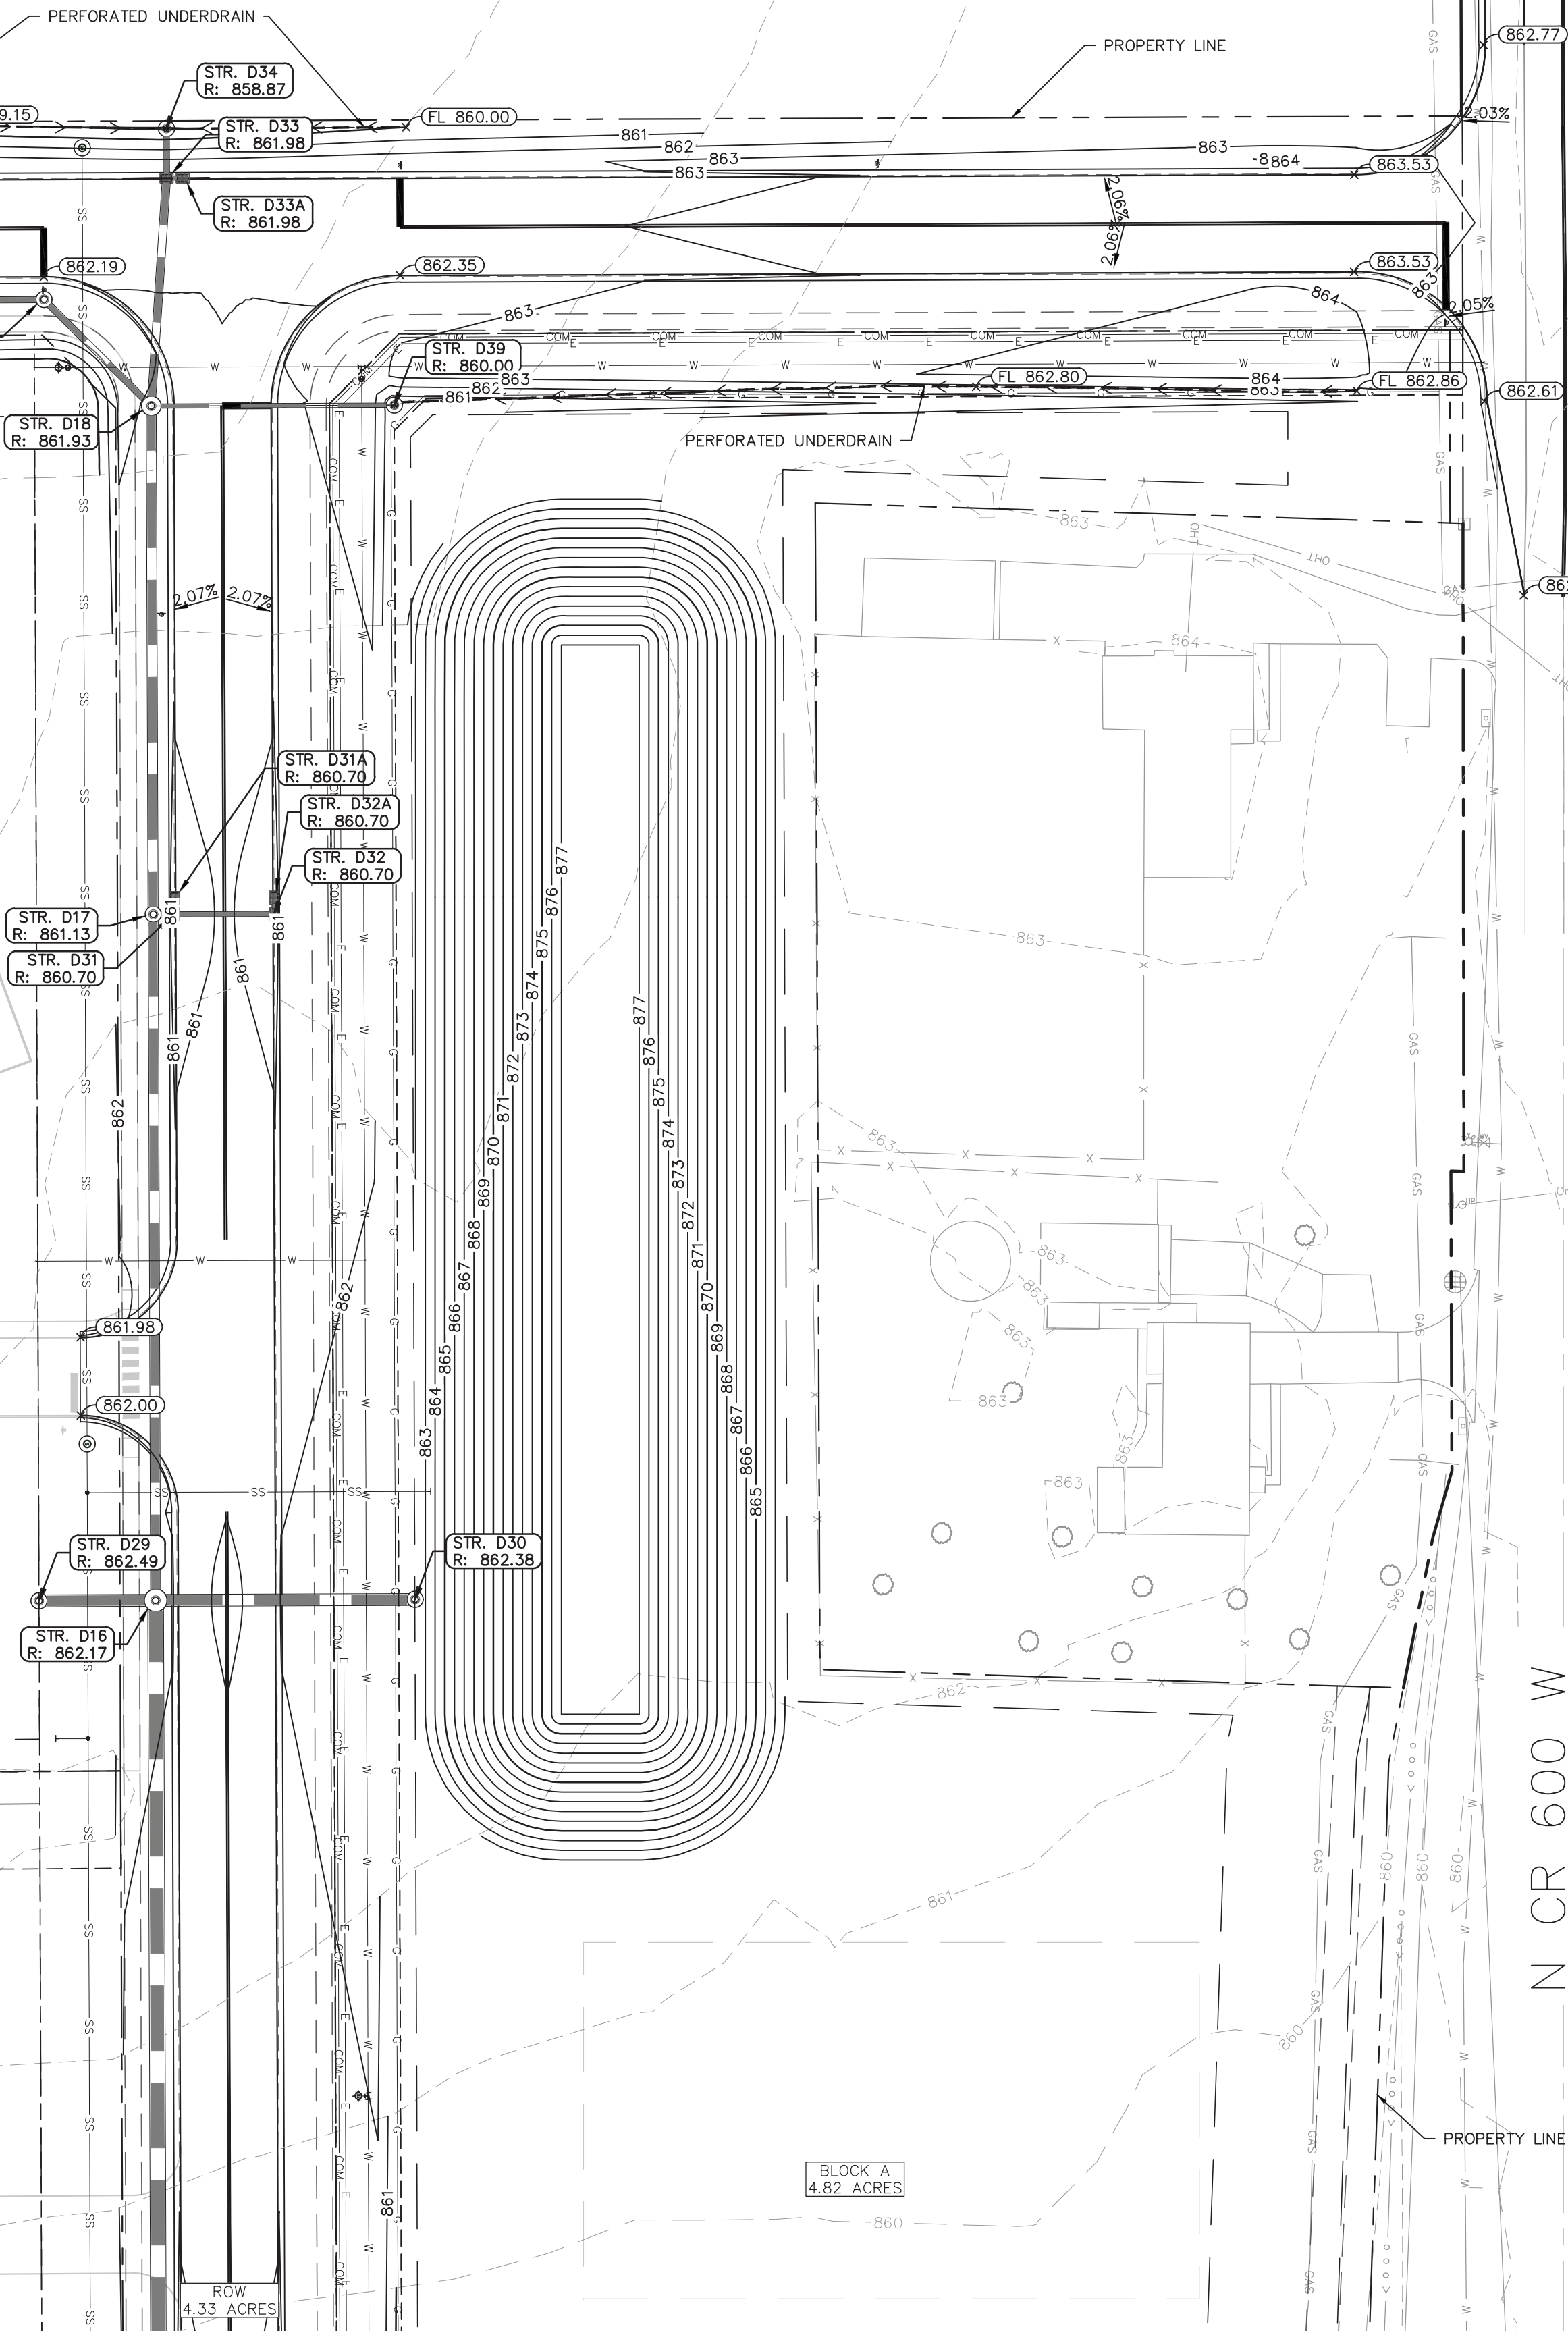


1
 2
 3
 525

MATCHLINE - SEE SHEET C5.1
MATCHLINE - SEE SHEET C5.3

Indiana Utilities Protection Service

Call 811
before you dig

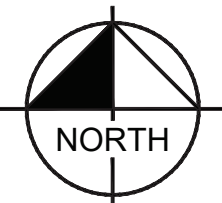

GRAPHIC SCALE IN FEET

A horizontal line with vertical tick marks at 0, 20, 40, and 80 feet. The segment between 0 and 20 is white. The segment between 20 and 40 is black. The segment between 40 and 80 is white.

GRADING LEGEND

- | | |
|--|---|
| | FINISHED GRADE SPOT ELEVATION |
| | TOP OF CURB / BOTTOM OF CURB SPOT ELEVATION |
| | FLOW LINE SPOT ELEVATION |
| | MATCH EXISTING SPOT ELEVATION |
| | FINISHED FLOOR SPOT ELEVATION |
| | FINISHED GRADE NEAR BUILDING SPOT ELEVATION |
| | TOP OF WALL SPOT ELEVATION |
| | BOTTOM OF WALL SPOT ELEVATION |
| | RIM ELEVATION |
| | STRUCTURE ID & RIM ELEVATION |
| | STRUCTURE ID & INVERT ELEVATION |
| | PROPOSED CONTOUR |
| | RIDGE LINE |
| | SLOPE AND FLOW DIRECTION |
| | 100-YEAR OVERLAND OVERFLOW ROUTE |
| | DETENTION BASIN 100-YEAR EMERGENCY |
| | PROPOSED SWALE |
| | PROPOSED STORM SEWER |
| | PROPOSED STORM STRUCTURES |
| | PROPOSED SANITARY MANHOLE |
| | PROPOSED STORM/SANITARY CLEANOUT |
| | PROPOSED WATER STRUCTURES |
| | PROPOSED LIGHT POLES |
| | PROPOSED TRANSFORMER PAD |

MATCHLINE - SEE SHEET C5.3

MATCHLINE - SEE SHEET C5.4

GENERAL PLAN NOTES

REFER TO GENERAL NOTES SHEET FOR MORE INFORMATION INCLUDING THE FOLLOWING: (EXISTING LEGEND, BENCHMARK INFORMATION, AND SPECIFIC GENERAL PLAN NOTES.)

TAC COMMENTS	06/03/25	TNH
--------------	----------	-----

06/03/25	TNH
----------	-----

△	TAC COMMENTS	06/03/25	TNH
---	--------------	----------	-----

Kimley»Horn
©2025 KIMLEY-HORN AND ASSOCIATES, INC.
500 EAST 96TH STREET, SUITE 300,
INDIANAPOLIS, IN 46240
PHONE: 317-218-9560
WWW.KIMLEY-HORN.COM

SCALE:	AS NOTED
DESIGNED BY:	DJZ
DRAWN BY:	DJZ
CHECKED BY:	NPK

PATCH

DEVELOPMENT

GRADING AND DRAINAGE PLAN PHASE 1

GATEWAY AT MCCORDSVILLE
MASS GRADING & PUBLIC
INFRASTRUCTURE


ORIGINAL ISSUE:

05/02/2025
KHA PROJECT NO
170125008

SHEET NUMBER

C5.3

Drawing name: K:\IND_LDEV\170125008_patch_nwc-600w650p_mccordsville_ind\2 Design\CADD\plansheets\RI.0-TYPICAL-SECTIONS.dwg Jun 03, 2025 2:36pm by: ELLIAPS
This document, together with the concepts and designs presented herein, is intended only for the specific purpose and client for which it was prepared. Reuse of and improper reliance on this document without written authorization and adaptation by Kimley-Horn and Associates, Inc. shall be without liability to Kimley-Horn and Associates, Inc.

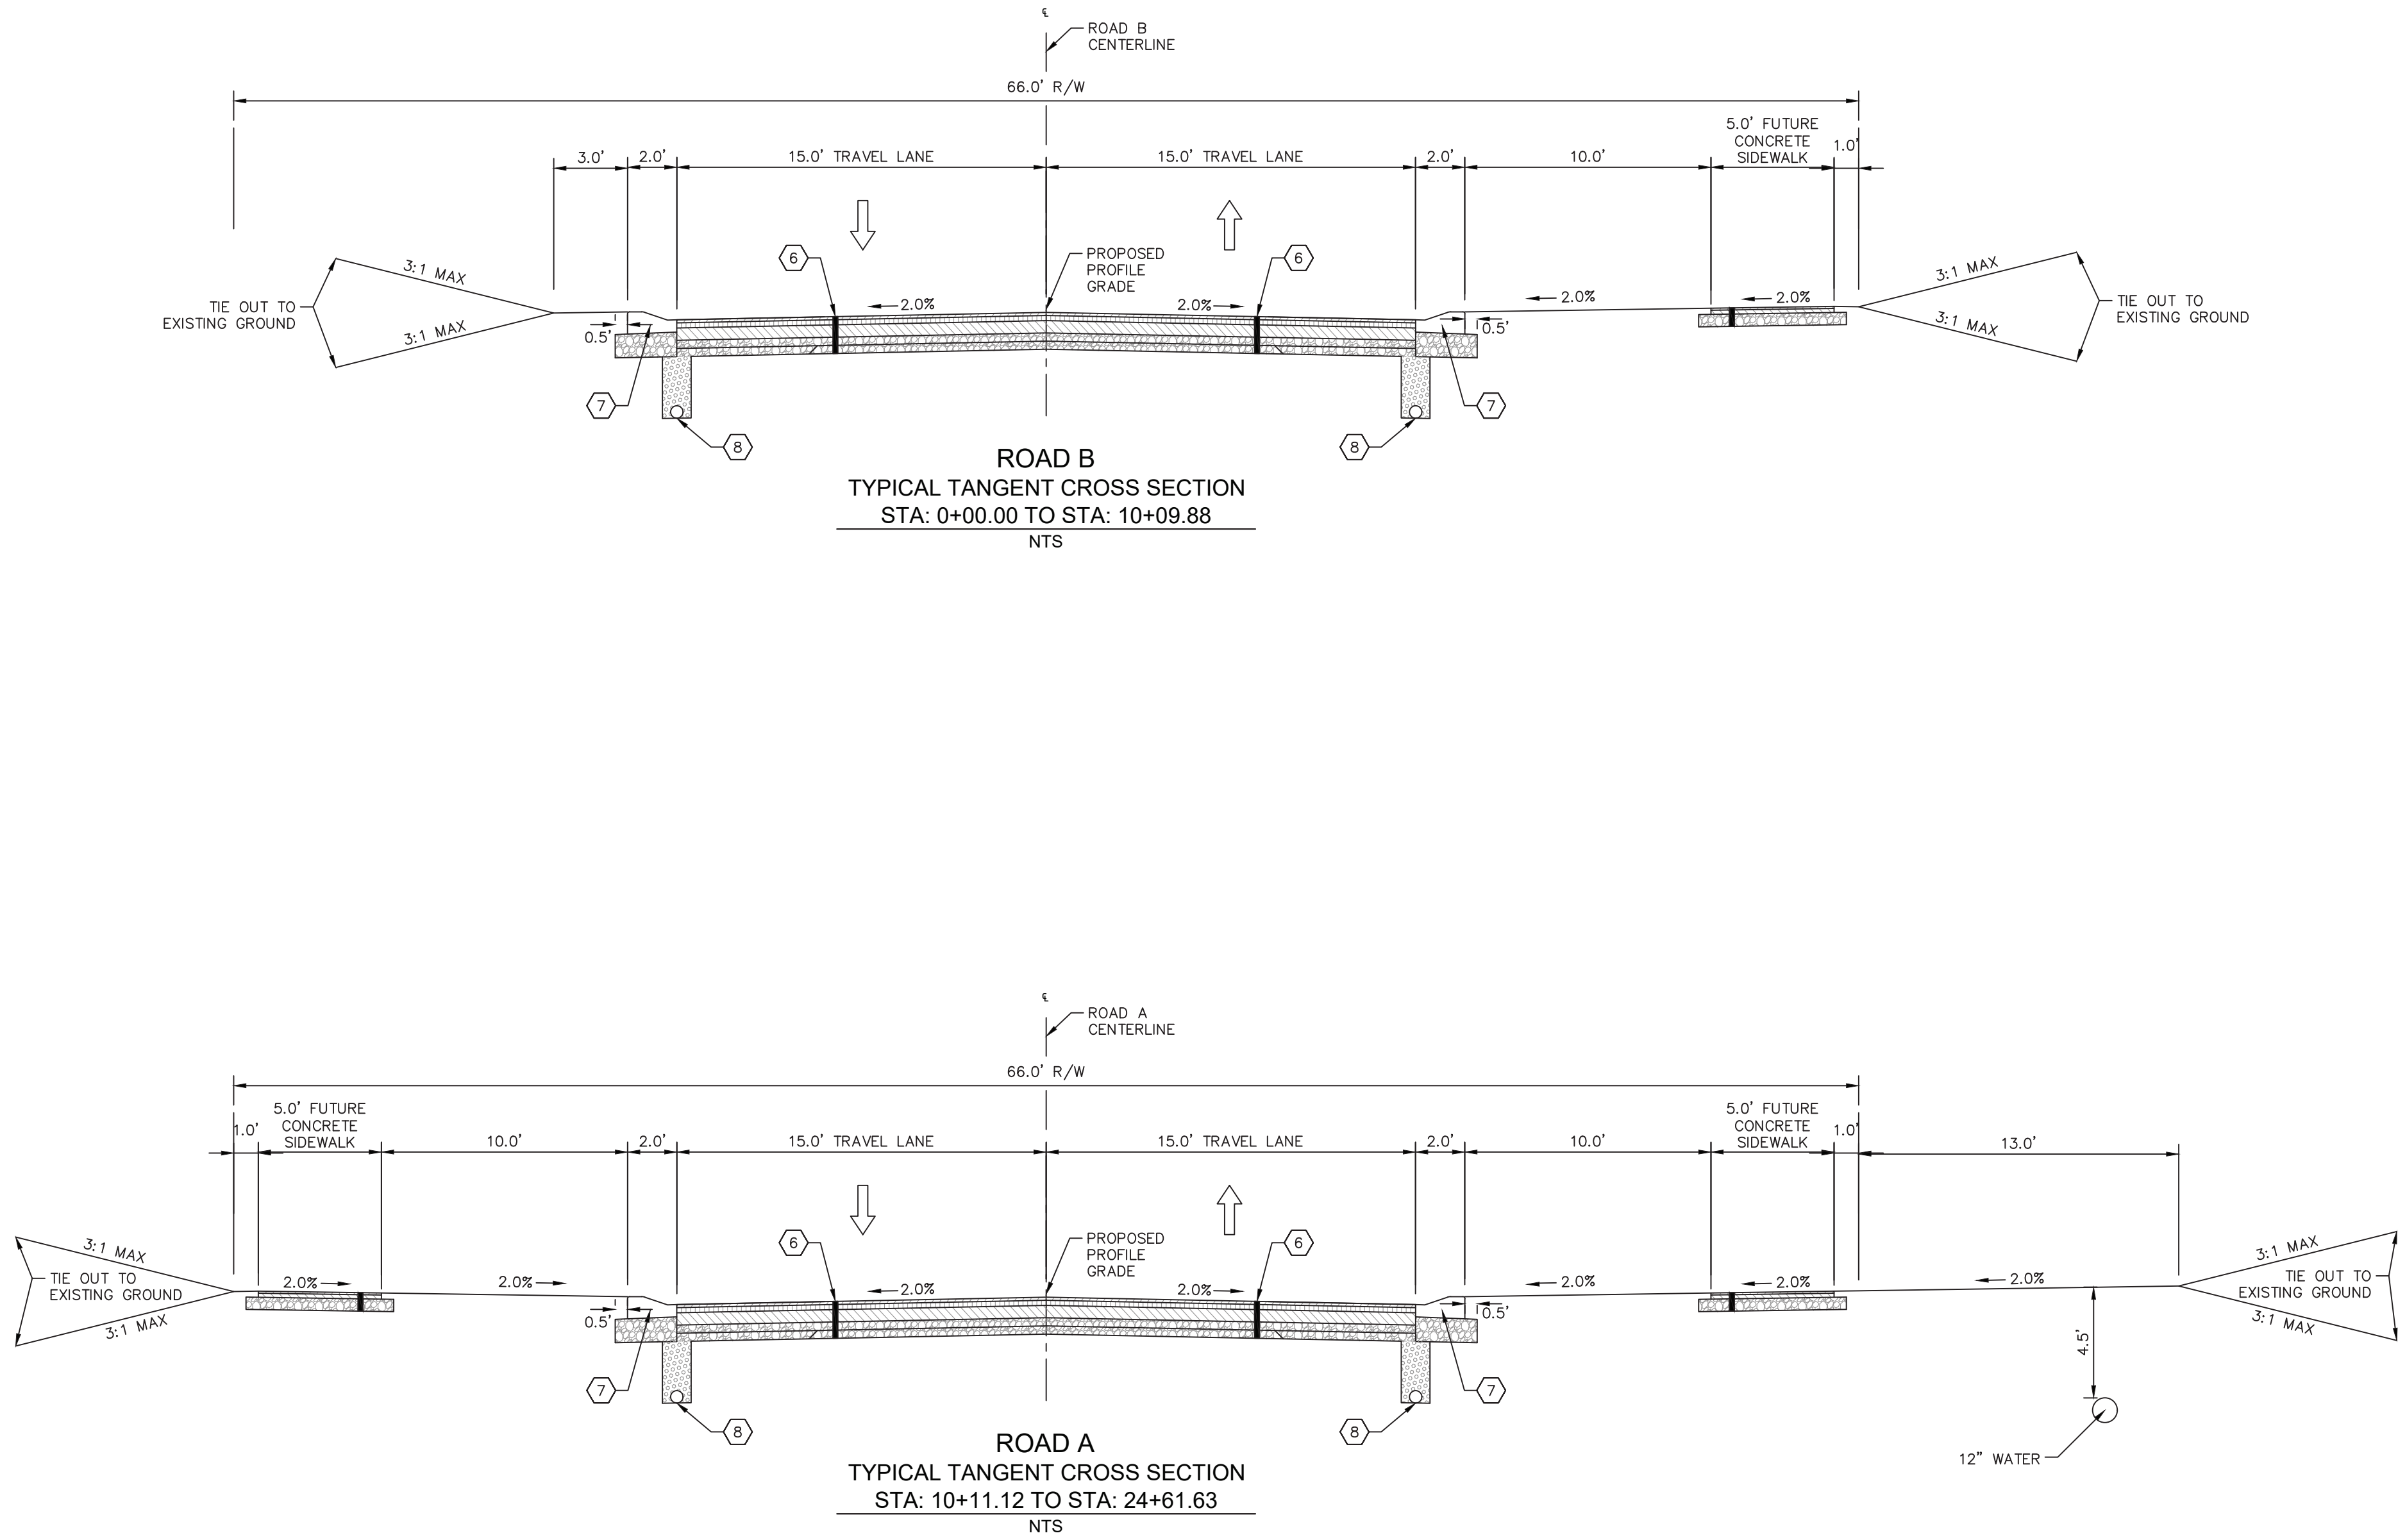

LEGEND

1

MILLING, ASPHALT, 1.5 IN. THEN
165 LBS/SYS, QC/QA-HMA, SURFACE, 9.5 mm

2

MILLING, ASPHALT, 1.5 IN. THEN
VARIABLE DEPTH (165 TO 350 LBS/SYS), QC/QA-HMA, SURFACE, 9.5 mm

3

165 LBS/SYS, QC/QA-HMA, SURFACE, 9.5 mm ON
275 LBS/SYS, QC/QA-HMA, INTERMEDIATE, 19.0 mm ON
440 LBS/SYS, QC/QA-HMA, BASE, 25.0 mm ON
660 LBS/SYS, QC/QA-HMA, BASE, 25.0 mm ON
4 IN. COMPACTED AGGREGATE BASE, NO. 53 ON
4 IN. COMPACTED AGGREGATE, NO. 2 STONE ON
SUBGRADE TREATMENT TYPE 1B (CHEMICALLY MODIFIED WITH 4.5%
HIGH CALCIUM HYDRATED LIME OR CEMENT)

4

5 IN. P.C. CONCRETE PAVEMENT ON
4 IN. COMPACTED AGGREGATE BASE, NO. 53 ON
SUBGRADE-SCARIFIED AND COMPACTED TO AT LEAST 95% OF THE MODIFIED
PROCTOR MAXIMUM DRY DENSITY

5

NOT USED

6

165 LBS/SYS, QC/QA-HMA, SURFACE, 9.5 mm ON
275 LBS/SYS, QC/QA-HMA, INTERMEDIATE, 19.0 mm ON
660 LBS/SYS, QC/QA-HMA, BASE, 25.0 mm ON
4 IN. COMPACTED AGGREGATE BASE, NO. 53 ON
4 IN. COMPACTED AGGREGATE, NO. 2 STONE ON
SUBGRADE TREATMENT TYPE 1B (CHEMICALLY MODIFIED WITH 4.5%
HIGH CALCIUM HYDRATED LIME OR CEMENT)

7


ROLL CURB AND GUTTER
(SEE TOWN OF MCCORDSVILLE TOWN STANDARDS, SHEET 3)

8

6" UNDERDRAIN
(SEE TOWN OF MCCORDSVILLE TOWN STANDARDS, SHEET 3)


GATEWAY AT MCCORDSVILLE MASS GRADING & PUBLIC INFRASTRUCTURE NWC OF N 600 W & W 500 N, MCCORDSVILLE, IN 46055		TYPICAL SECTIONS		PATCH DEVELOPMENT				 ©2025 KIMLEY-HORN AND ASSOCIATES, INC. 500 EAST 96TH STREET, SUITE 300, INDIANAPOLIS, IN 46240 WWW.KIMLEY-HORN.COM		SCALE: AS NOTED DESIGNED BY: DJZ DRAWN BY: DJZ CHECKED BY: NPK		TAC COMMENTS		06/03/25		TNH	
ORIGINAL ISSUE: 05/02/2025						SHEET NUMBER						R1.0					
KHA PROJECT NO. 170125008																	
REVISIONS						REVISIONS						DATE		BY			
												No.					

Drawing name: K:\IND_LEV\170125008_mccordsville_rnc-600w650p_mccordsville_rnc-600w650p-ALIGNED DATA.dwg R2.0 ALIGNMENT DATA Jun 03, 2025 2:36pm by Ellipsis
This document, together with the concepts and designs presented herein, is intended only for the specific purpose and client for which it was prepared. Reuse of and improper reliance on this document without written authorization and adaptation by Kimley-Horn and Associates, Inc. shall be without liability to Kimley-Horn and Associates, Inc.

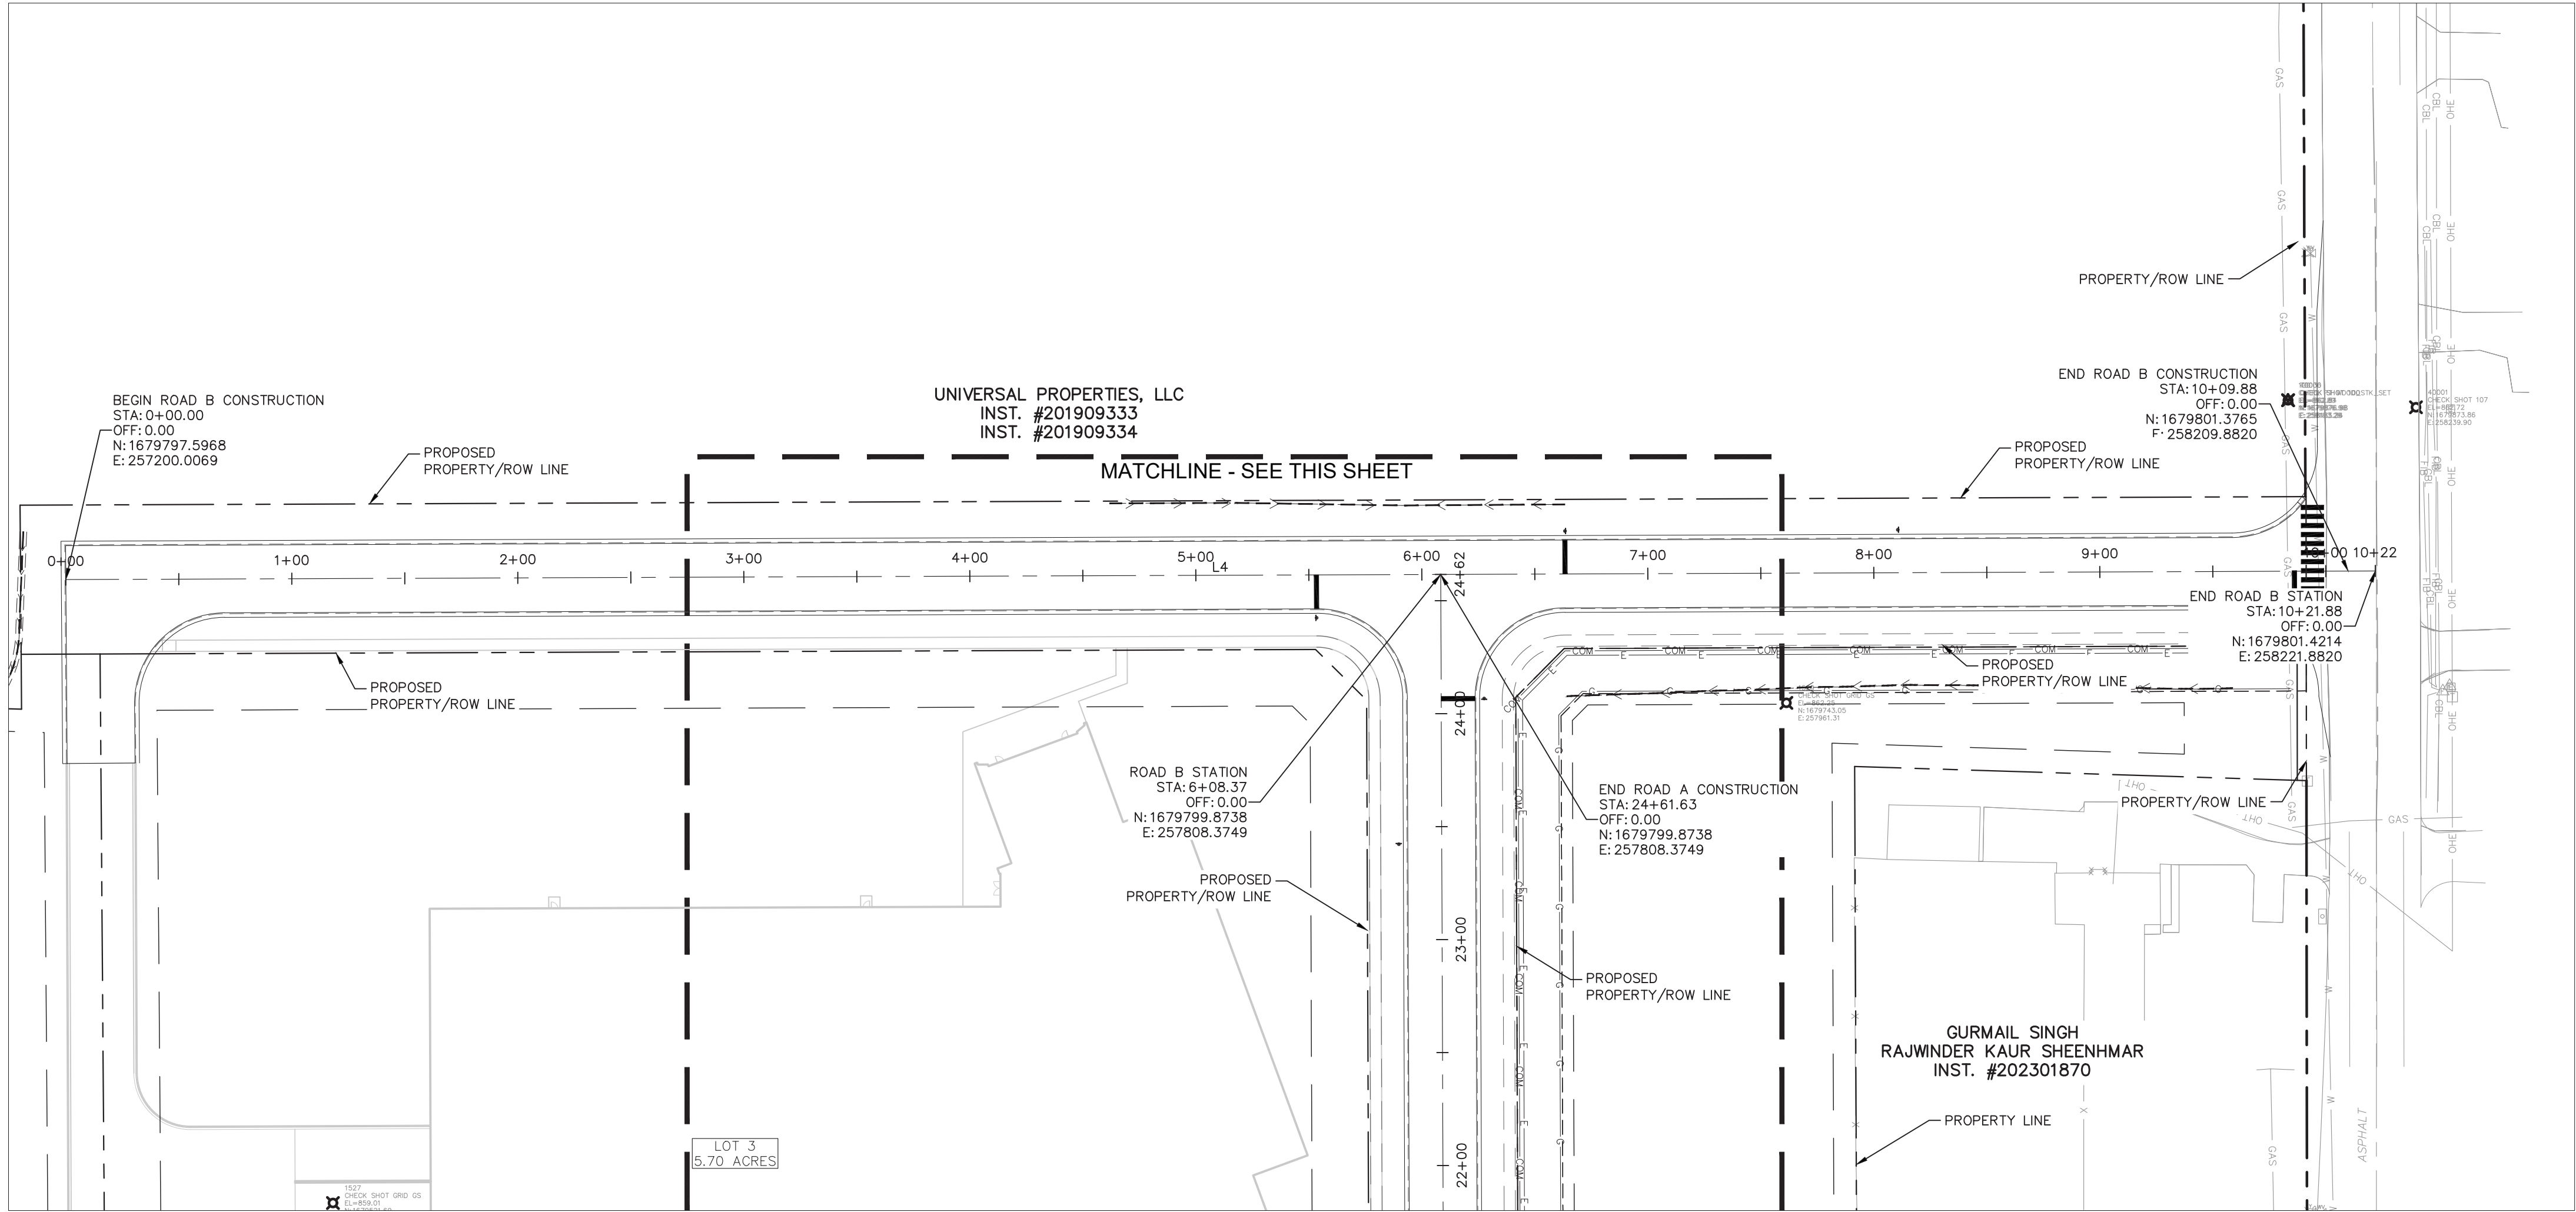

LINE TABLE		
LINE	LENGTH	BEARING
L1	105.94	N0°12'52.00"W
L2	17.72	N44°47'08.00"E
L3	803.11	N0°12'52.00"W
L4	1021.88	N89°47'08.00"E

CURVE TABLE						
CURVE	RADIUS	LENGTH	CHORD BEARING	CHORD	DELTA	TANGENT
C1	333.00'	261.54'	N22°17'08"E	254.87'	45°00'00"	137.93'
C2	348.00'	273.32'	N22°17'08"E	266.35'	45°00'00"	144.15'

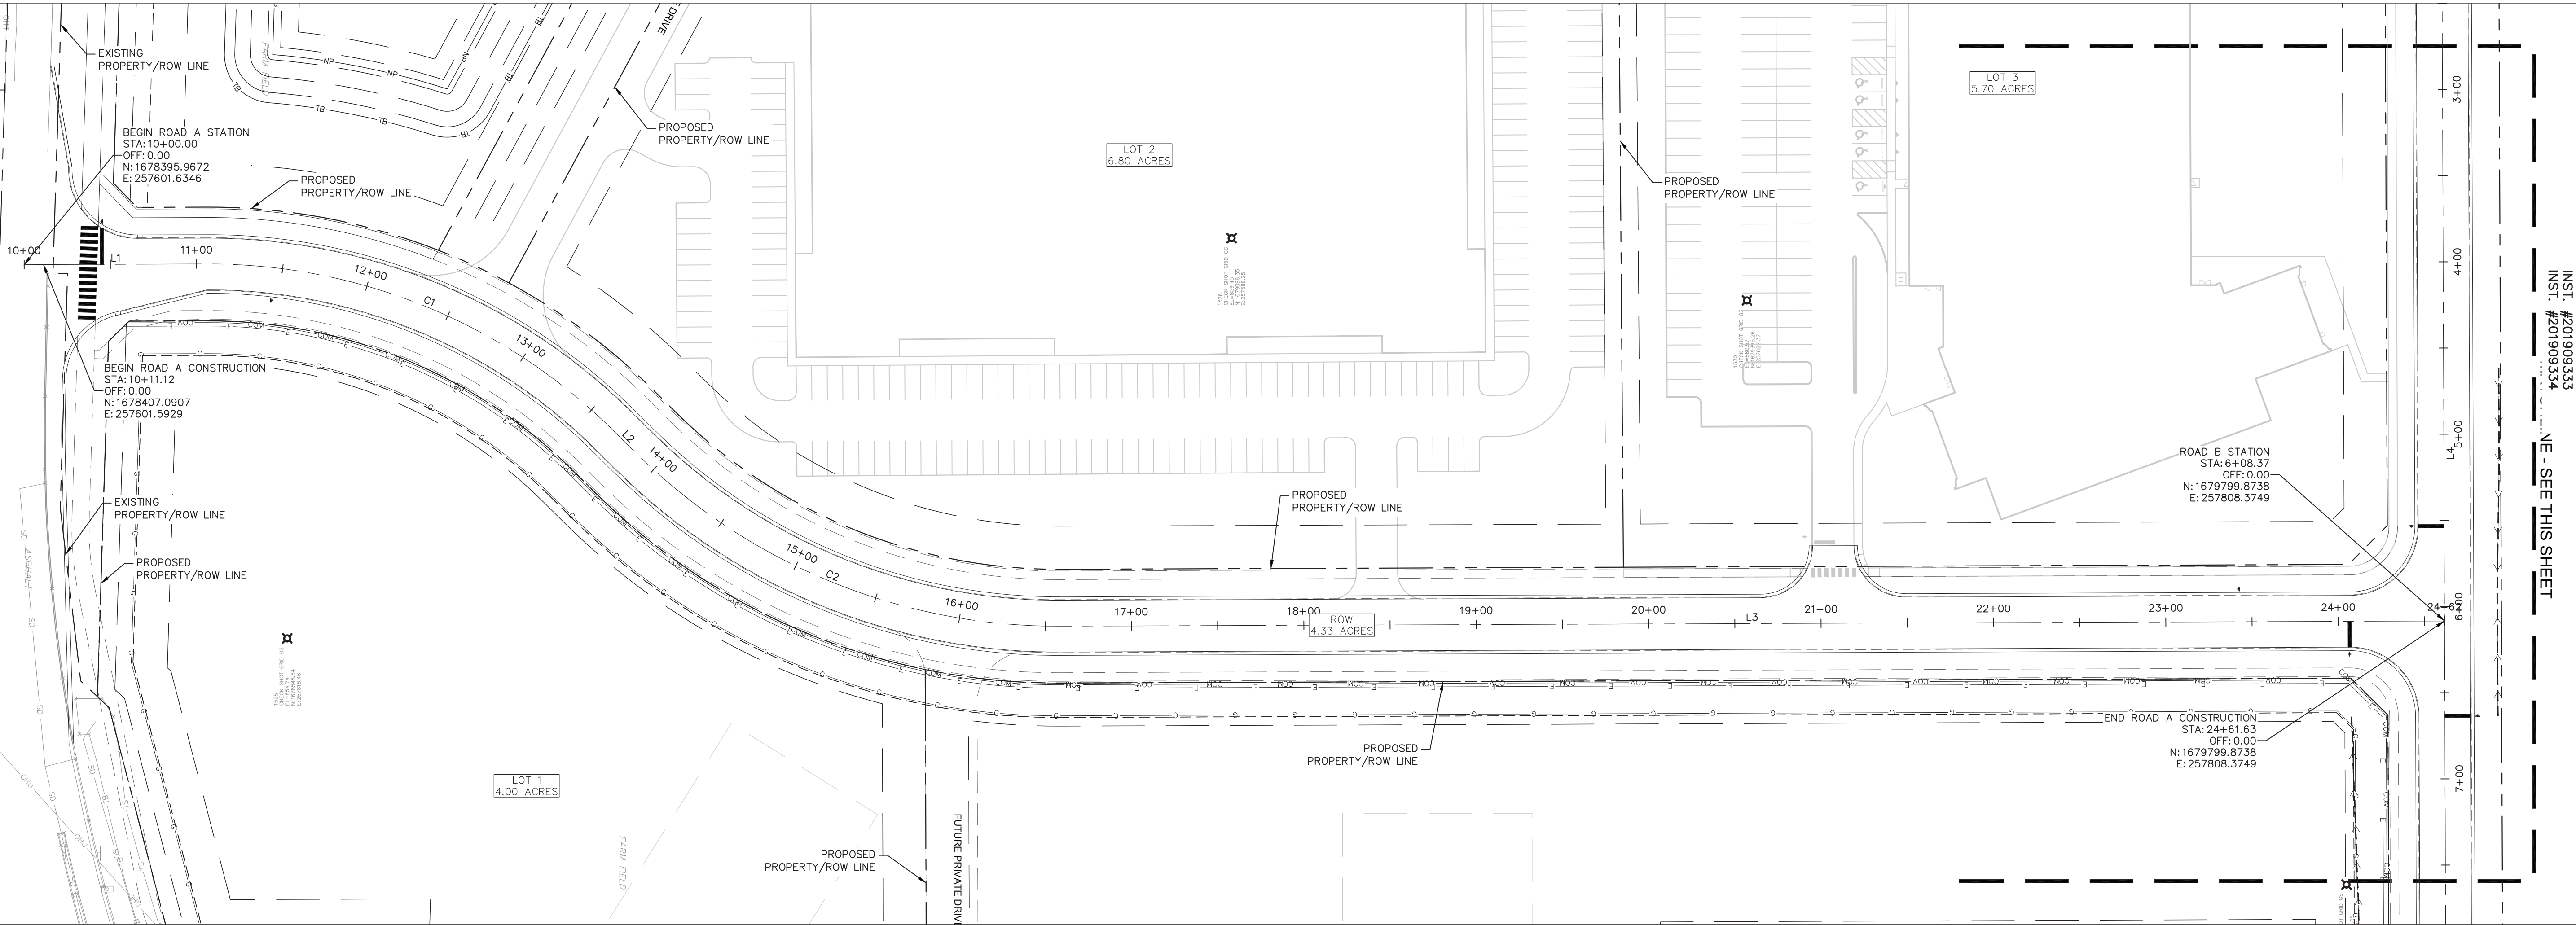


GATEWAY AT MCCORDSVILLE
MASS GRADING & PUBLIC
INFRASTRUCTURE
NWC OF N 600 W & W 500 N,
MCCORDSVILLE, IN 46055

ORIGINAL ISSUE:
05/02/2025
KHA PROJECT NO.
170125008
SHEET NUMBER

R2.0


ALIGNMENT DATA

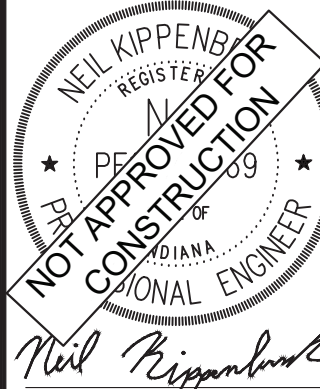

SCALE:
AS NOTED
DESIGNED BY: DJZ
DRAWN BY: DJZ
CHECKED BY: NPK


Kimley»Horn
©2025 KIMLEY-HORN AND ASSOCIATES, INC.
500 EAST 96TH STREET, SUITE 300,
INDIANAPOLIS, IN 46240
WWW.KIMLEY-HORN.COM

TAC COMMENTS	DATE	BY
	06/03/25	TNH

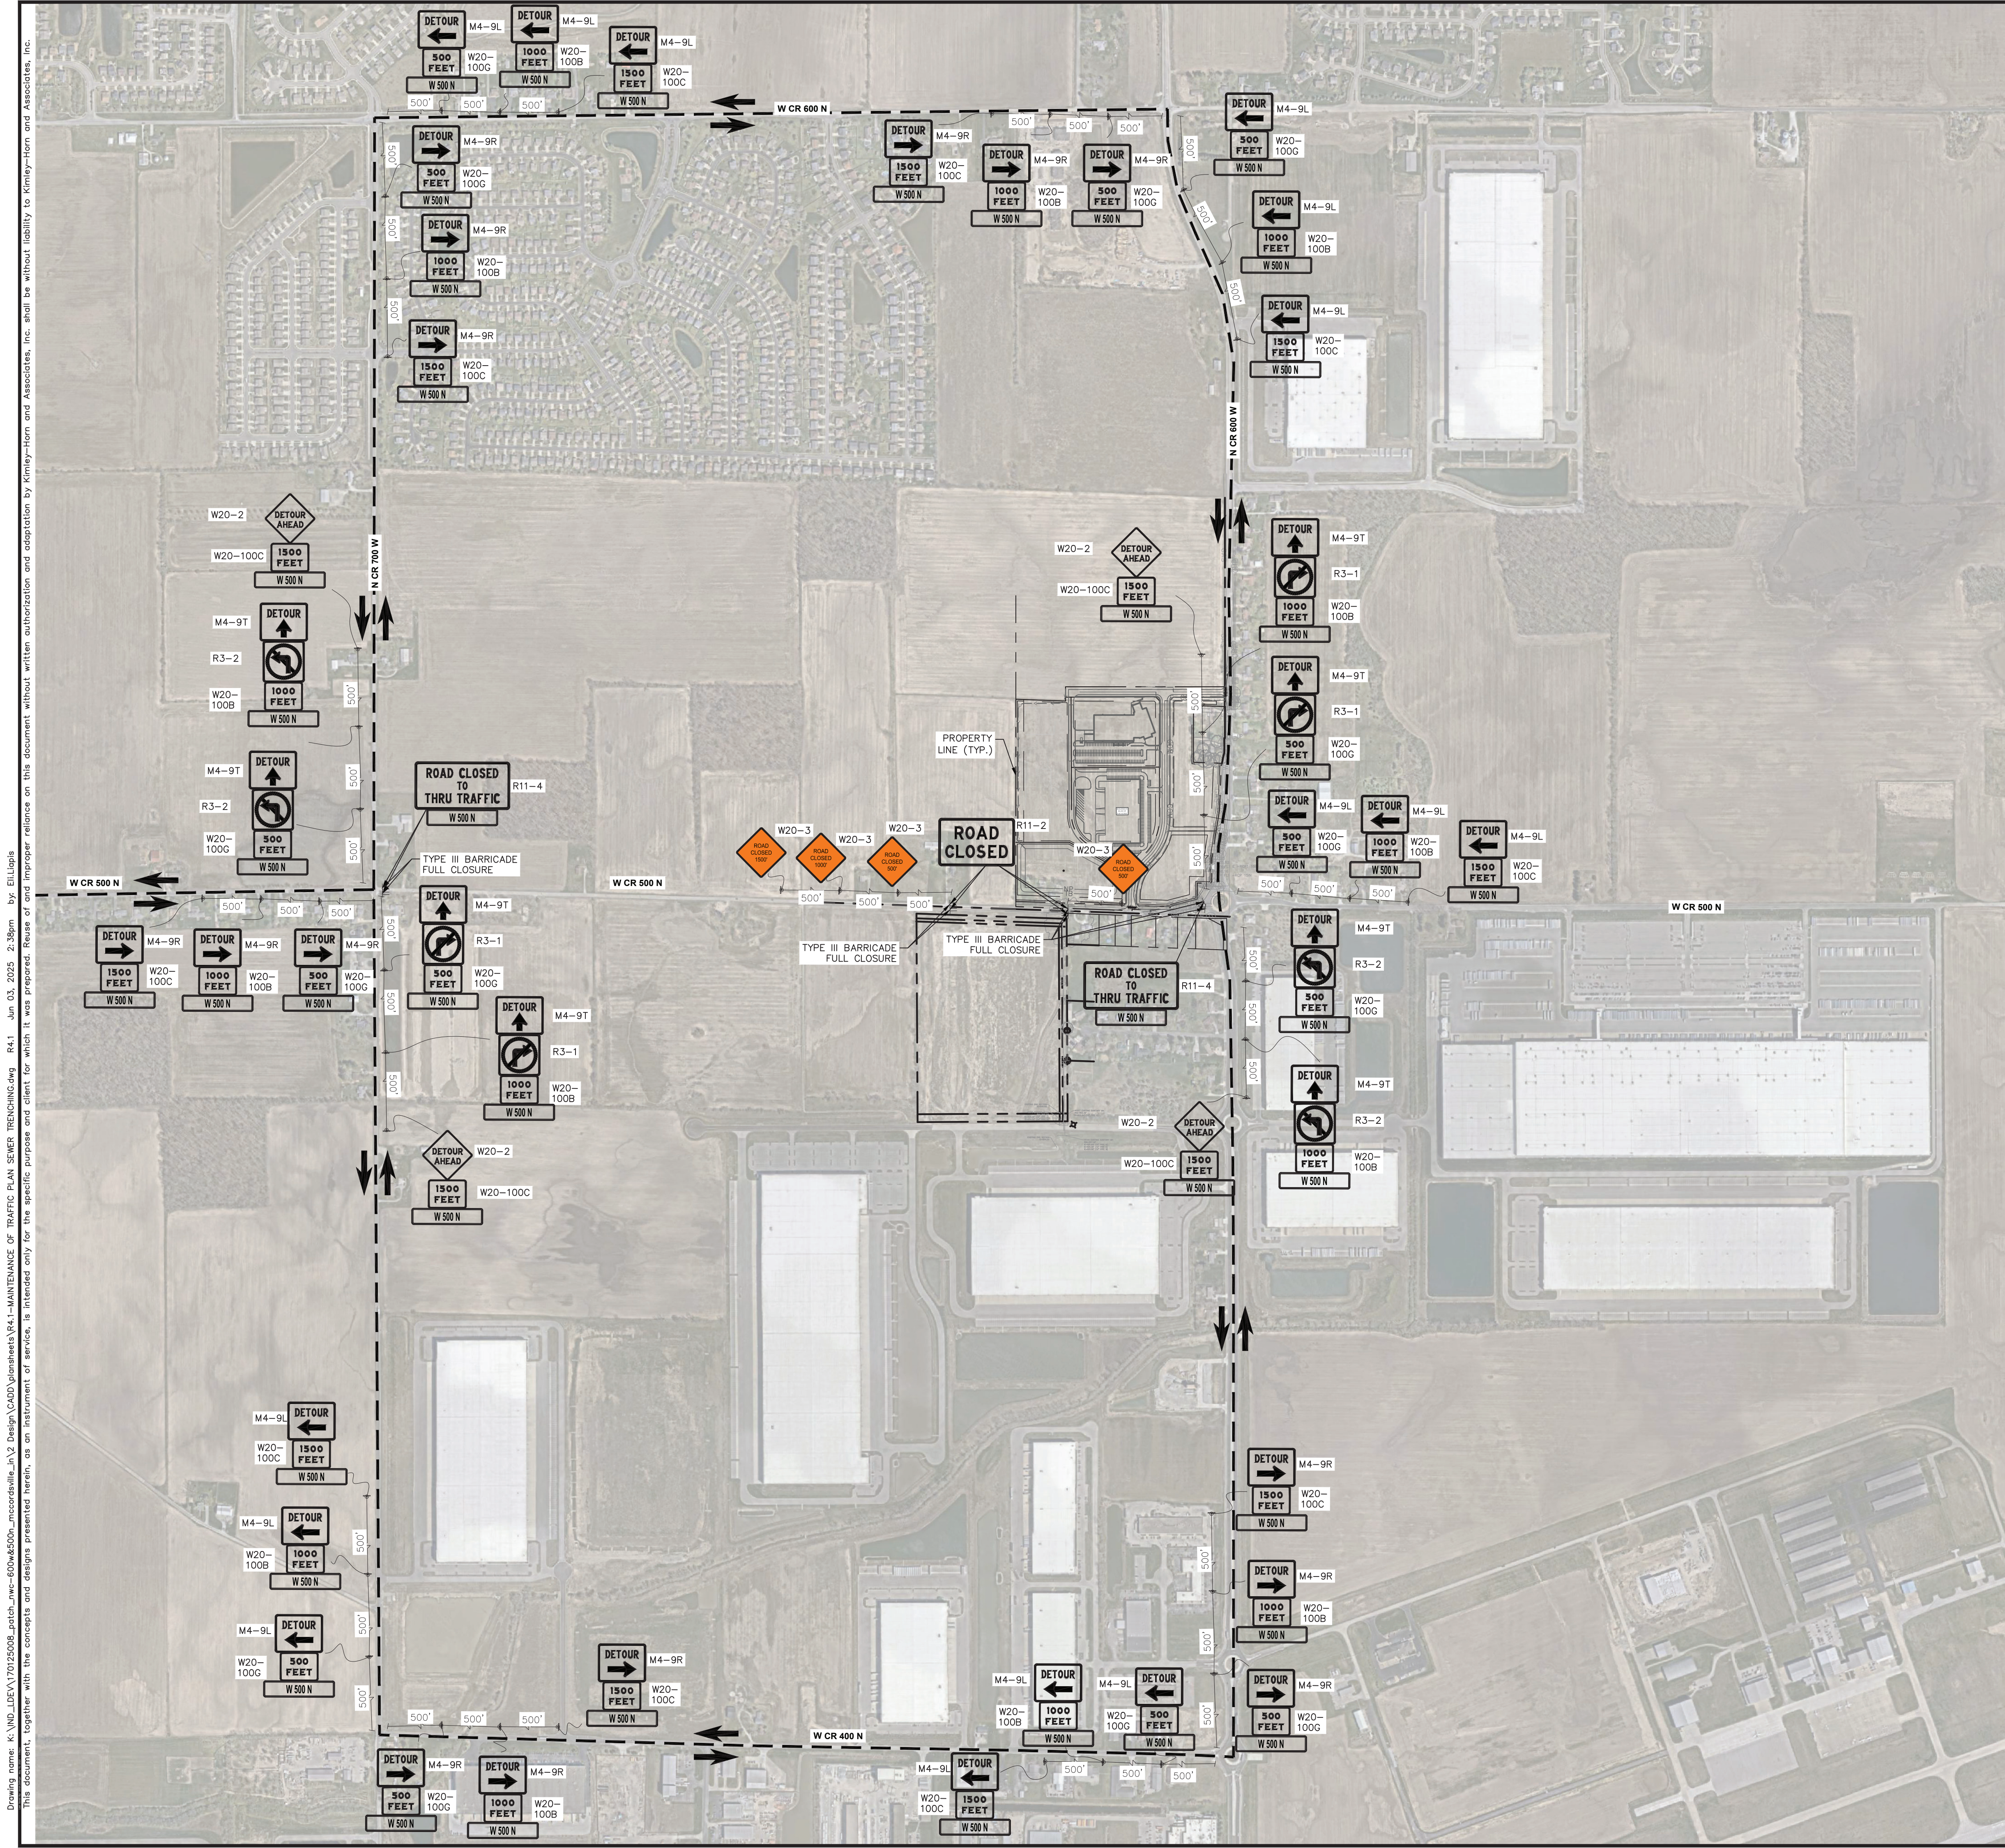

Indiana Utilities Protection Service

Call 811
before you dig

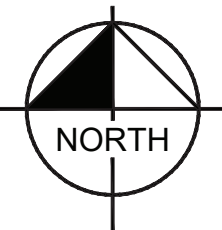

GRAPHIC SCALE IN FEET
0 250' 500' 1000'

LEGEND


- WORK ZONE
- TRAFFIC FLOW
- TRAFFIC SPACE
- ALTERNATE/DETOUR ROUTE
- CONSTRUCTION SIGN
- FLAGGER

GENERAL NOTES

- ALL WORK SHALL COMPLY WITH THE 2011 INDIANA MANUAL OF UNIFORM TRAFFIC CONTROL DEVICES INCLUDING REVISIONS 1, 2, AND 3.
- ALL AREAS EXCAVATED BELOW THE EXISTING PAVEMENT SURFACE AND WITHIN THE CLEAR ZONE AT THE CONCLUSION OF EACH WORKDAY, SHALL BE BACKFILLED TO FORM AN APPROXIMATE 6:1 WEDGE AGAINST THE EXISTING PAVEMENT OR NEWLY CONSTRUCTION PAVEMENT SURFACE FOR THE SAFETY AND PROTECTION OF VEHICULAR TRAFFIC.
- CHANNELIZING DEVICE SPACING SHALL BE AS FOLLOWS:
TRAVELWAY SPACING = 80'
TRANSITION SPACING = 40'
- ONE-WAY VEHICULAR TRAFFIC WITH A FLAGGER IS ONLY ALLOWED BETWEEN 9:00AM-3:00PM.

SEQUENCE OF CONSTRUCTION

- CONTRACTOR TO INSTALL ALL EROSION AND SEDIMENT CONTROL DEVICES PER THE EROSION CONTROL PLANS (SHEETS C4.0-C4.3).
- AFTER STEP 1, INSTALL TEMPORARY TRAFFIC CONTROL DEVICES AS REQUIRED AND GENERALLY AS SHOWN ON THIS PLAN.
- WORK ACTIVITIES GENERALLY CONSIST OF INSTALLATION OF DRAINAGE FEATURES, GRADINGS, PREPARATION OF PAVEMENT SUBGRADE, PAVING, AND TOPSOIL & SEED DISTURBED AREAS. ONLY SMITH ROAD WILL BE CONSTRUCTED.
- AFTER COMPLETION, REMOVE BARRIERS.

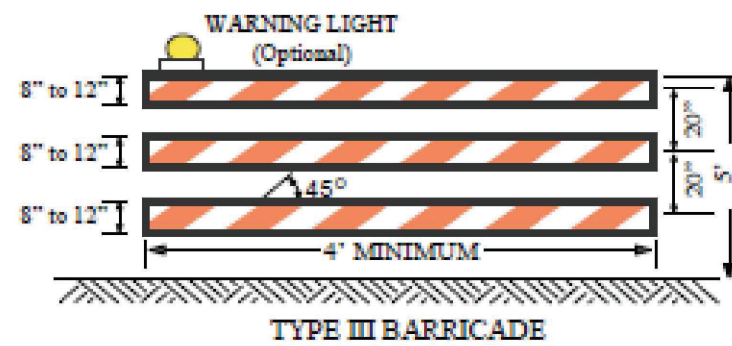


Notes:

- Stripes on barricade rails slope downward at an angle of 45 degrees toward the direction traffic is to pass.
- Barricade rail stripe widths shall be 6 inches except where rail lengths are less than 36 inches, then 4 inch wide stripes may be used.
- The sides of barricades facing traffic shall have retroreflective rail faces.
- All channelizing devices shall meet AASHTO Manual for Assessing Safety Hardware (MASH) Requirements.

GATEWAY AT MCCORDSVILLE MASS GRADING & PUBLIC INFRASTRUCTURE		ORIGINAL ISSUE: 05/02/2025 KHA PROJECT NO. 170125008		SHEET NUMBER R4.1		PATCH DEVELOPMENT				SCALE: AS NOTED DESIGNED BY: DJZ DRAWN BY: DJZ CHECKED BY: NPK		Kimley»Horn ©2025 KIMLEY-HORN AND ASSOCIATES, INC. 500 EAST 96TH STREET, SUITE 300, INDIANAPOLIS, IN 46240 WWW.KIMLEY-HORN.COM		TAC COMMENTS		06/03/25		TND	
										No.		REVISIONS		DATE		BY			

Drawing name: K:\IND\DEV\170125008_Patch_MCC-600W&500N_McCordsville\IN 2 Design\CADD\PlanSheets\L1.0-CONCEPTUAL LANDSCAPE PLAN.dwg L1.0 Jun 03, 2025 2:58pm by KatePaddock
This document, together with the concepts and designs presented herein, as an instrument of service, is intended only for the specific purpose and client for which it was prepared. Reuse of and improper reliance on this document without written authorization and adaptation by Kimley-Horn and Associates, Inc. shall be without liability to Kimley-Horn and Associates, Inc.

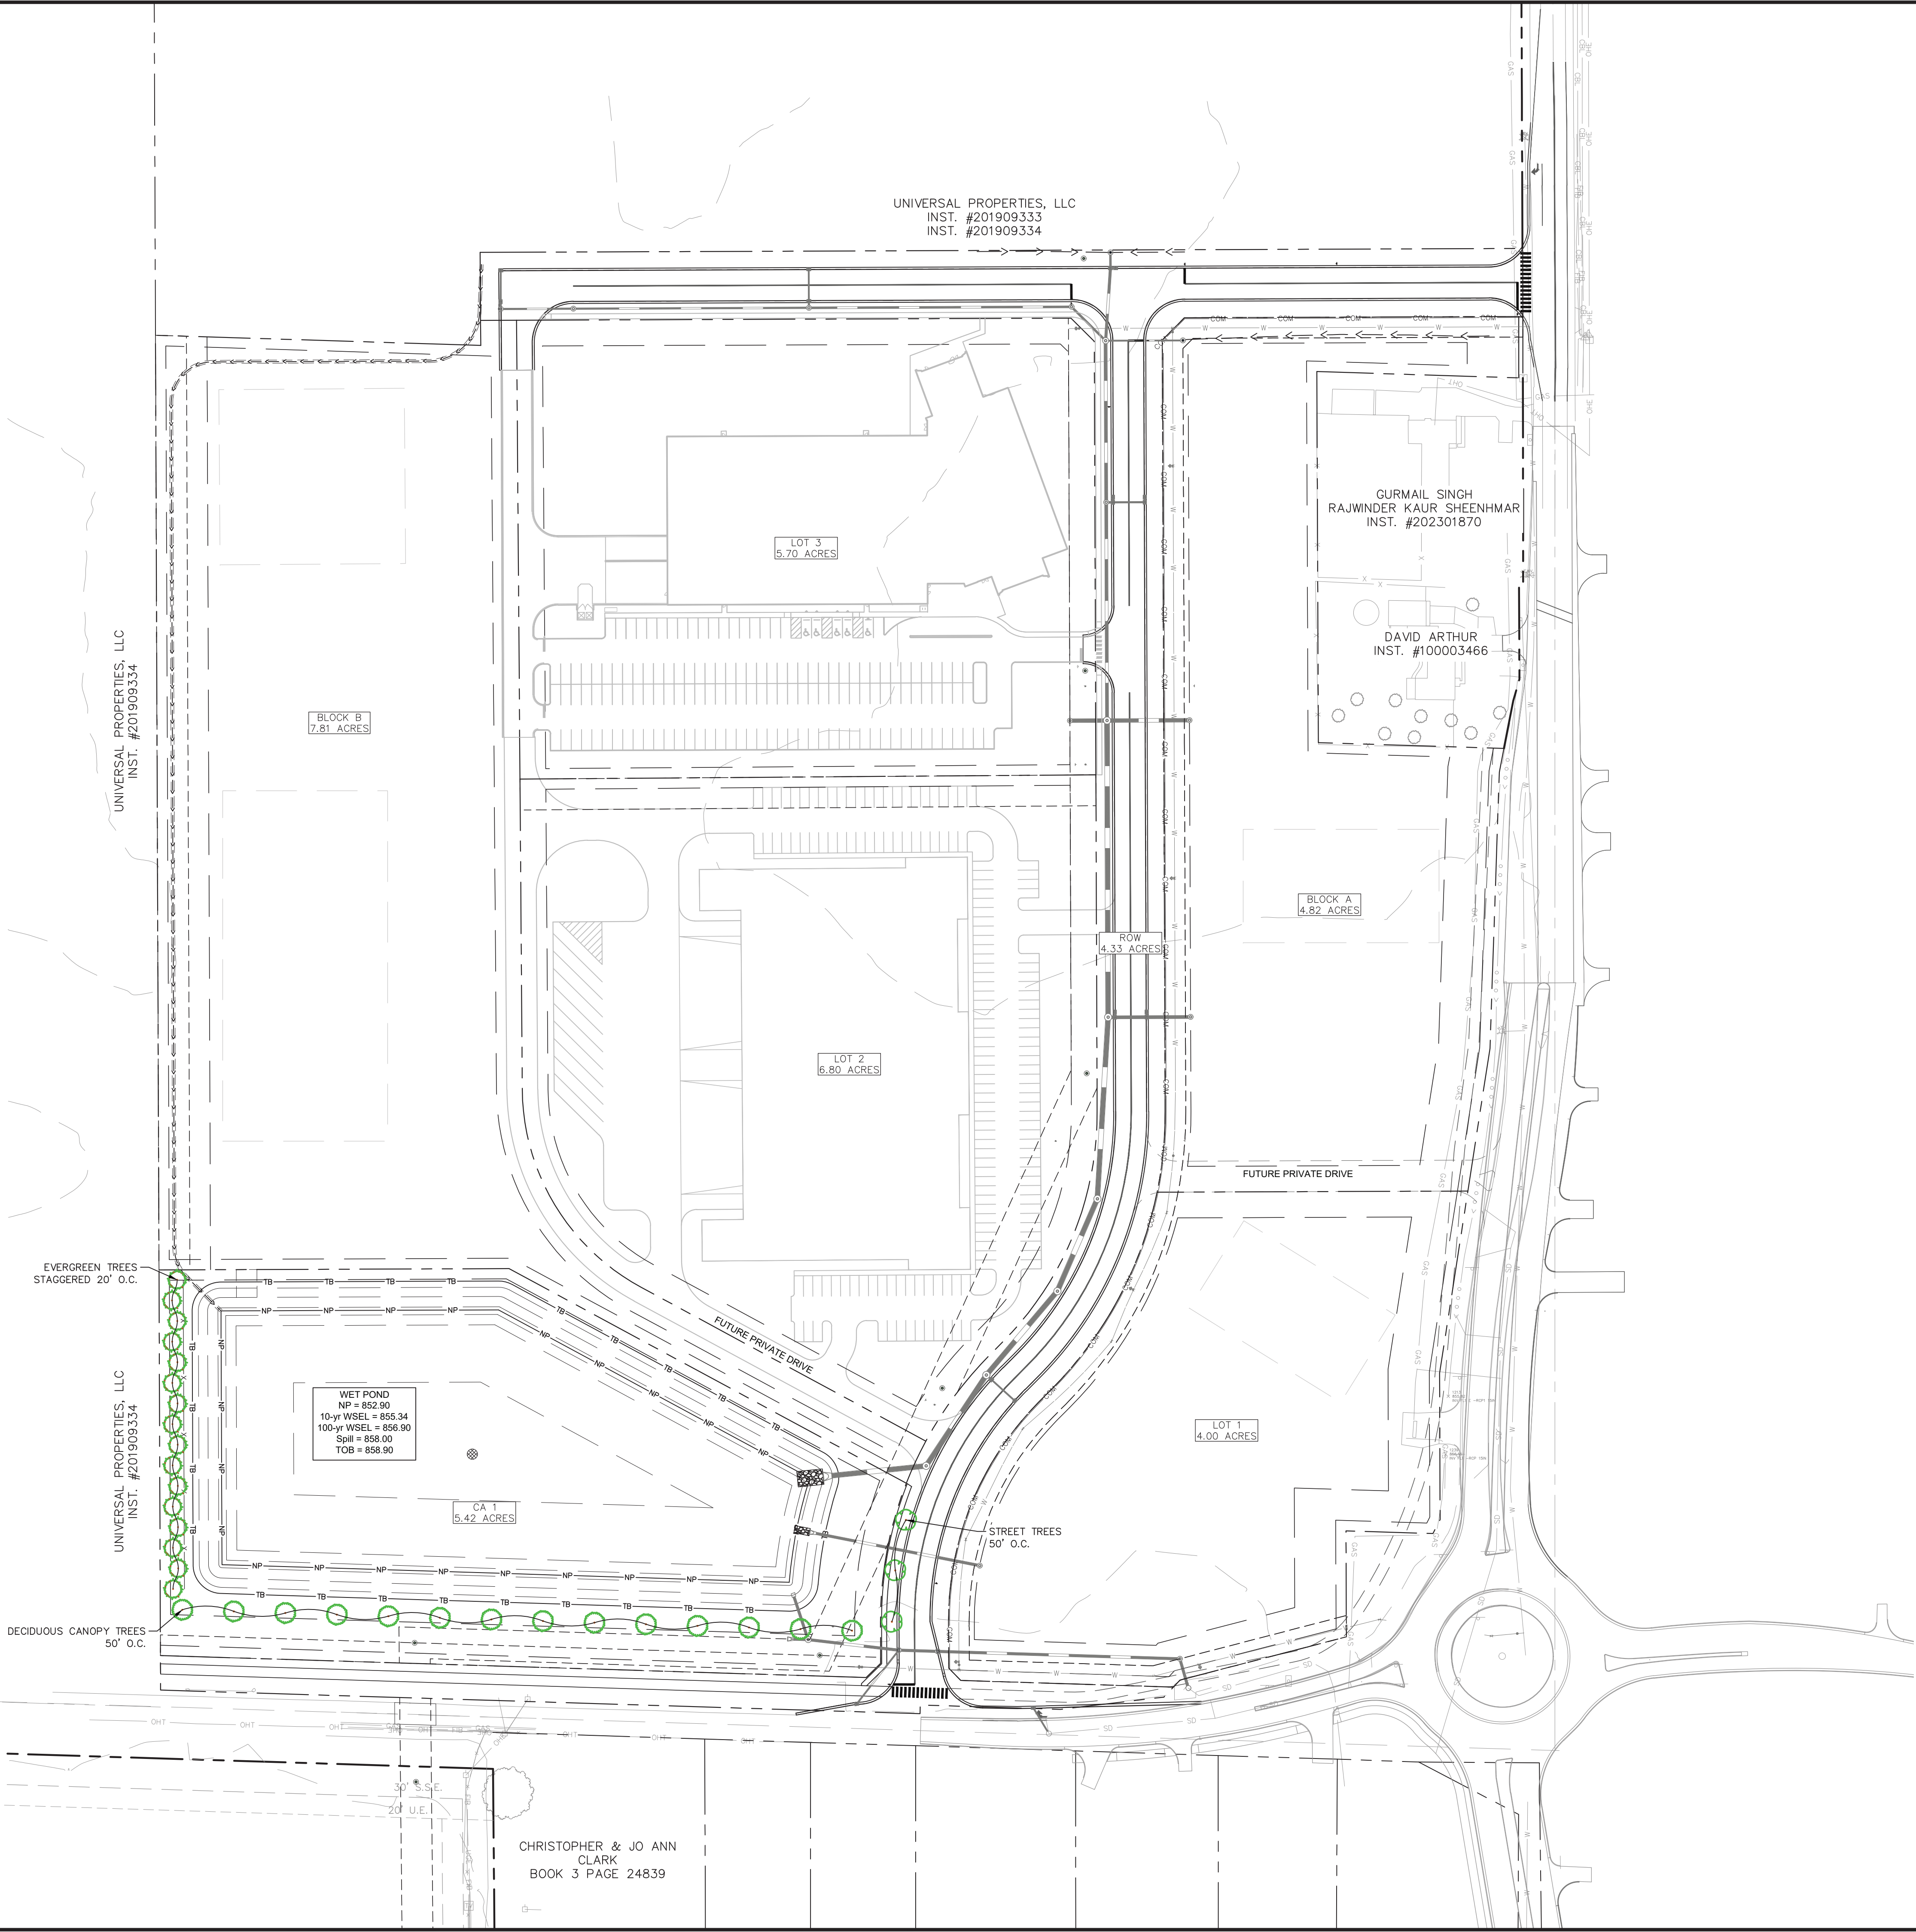

Indiana Utilities Protection Service


Call 811
before you dig

NORTH

GRAPHIC SCALE IN FEET
0 40 80 160

GATEWAY AT MCCORDSVILLE MASS GRADING & PUBLIC INFRASTRUCTURE		CONCEPTUAL LANDSCAPE PLAN		PATCH DEVELOPMENT		NOT APPROVED FOR CONSTRUCTION NEIL KIPPENS REGISTERED PROFESSIONAL ENGINEER STATE OF INDIANA No. 12345 Neil Kippens		SCALE: AS NOTED DESIGNED BY: DJZ DRAWN BY: DJZ CHECKED BY: NPK		Kimley»Horn ©2025 KIMLEY-HORN AND ASSOCIATES, INC. 500 EAST 96TH STREET, SUITE 300, INDIANAPOLIS, IN 46240 WWW.KIMLEY-HORN.COM		TAC COMMENTS		06/03/25		TNH	
ORIGINAL ISSUE: 05/02/2025 KHA PROJECT NO. 170125008		SHEET NUMBER L1.0															
														REVISIONS		DATE	
														No.			

This document, together with the concepts and designs presented herein, as an instrument of service, is intended only for the specific purpose and client for which it was prepared. Reuse of and improper reliance on this document without written authorization and adaptation by Kinley-Horn and Associates, Inc., shall be without liability to Kinley-Horn and Associates, Inc.

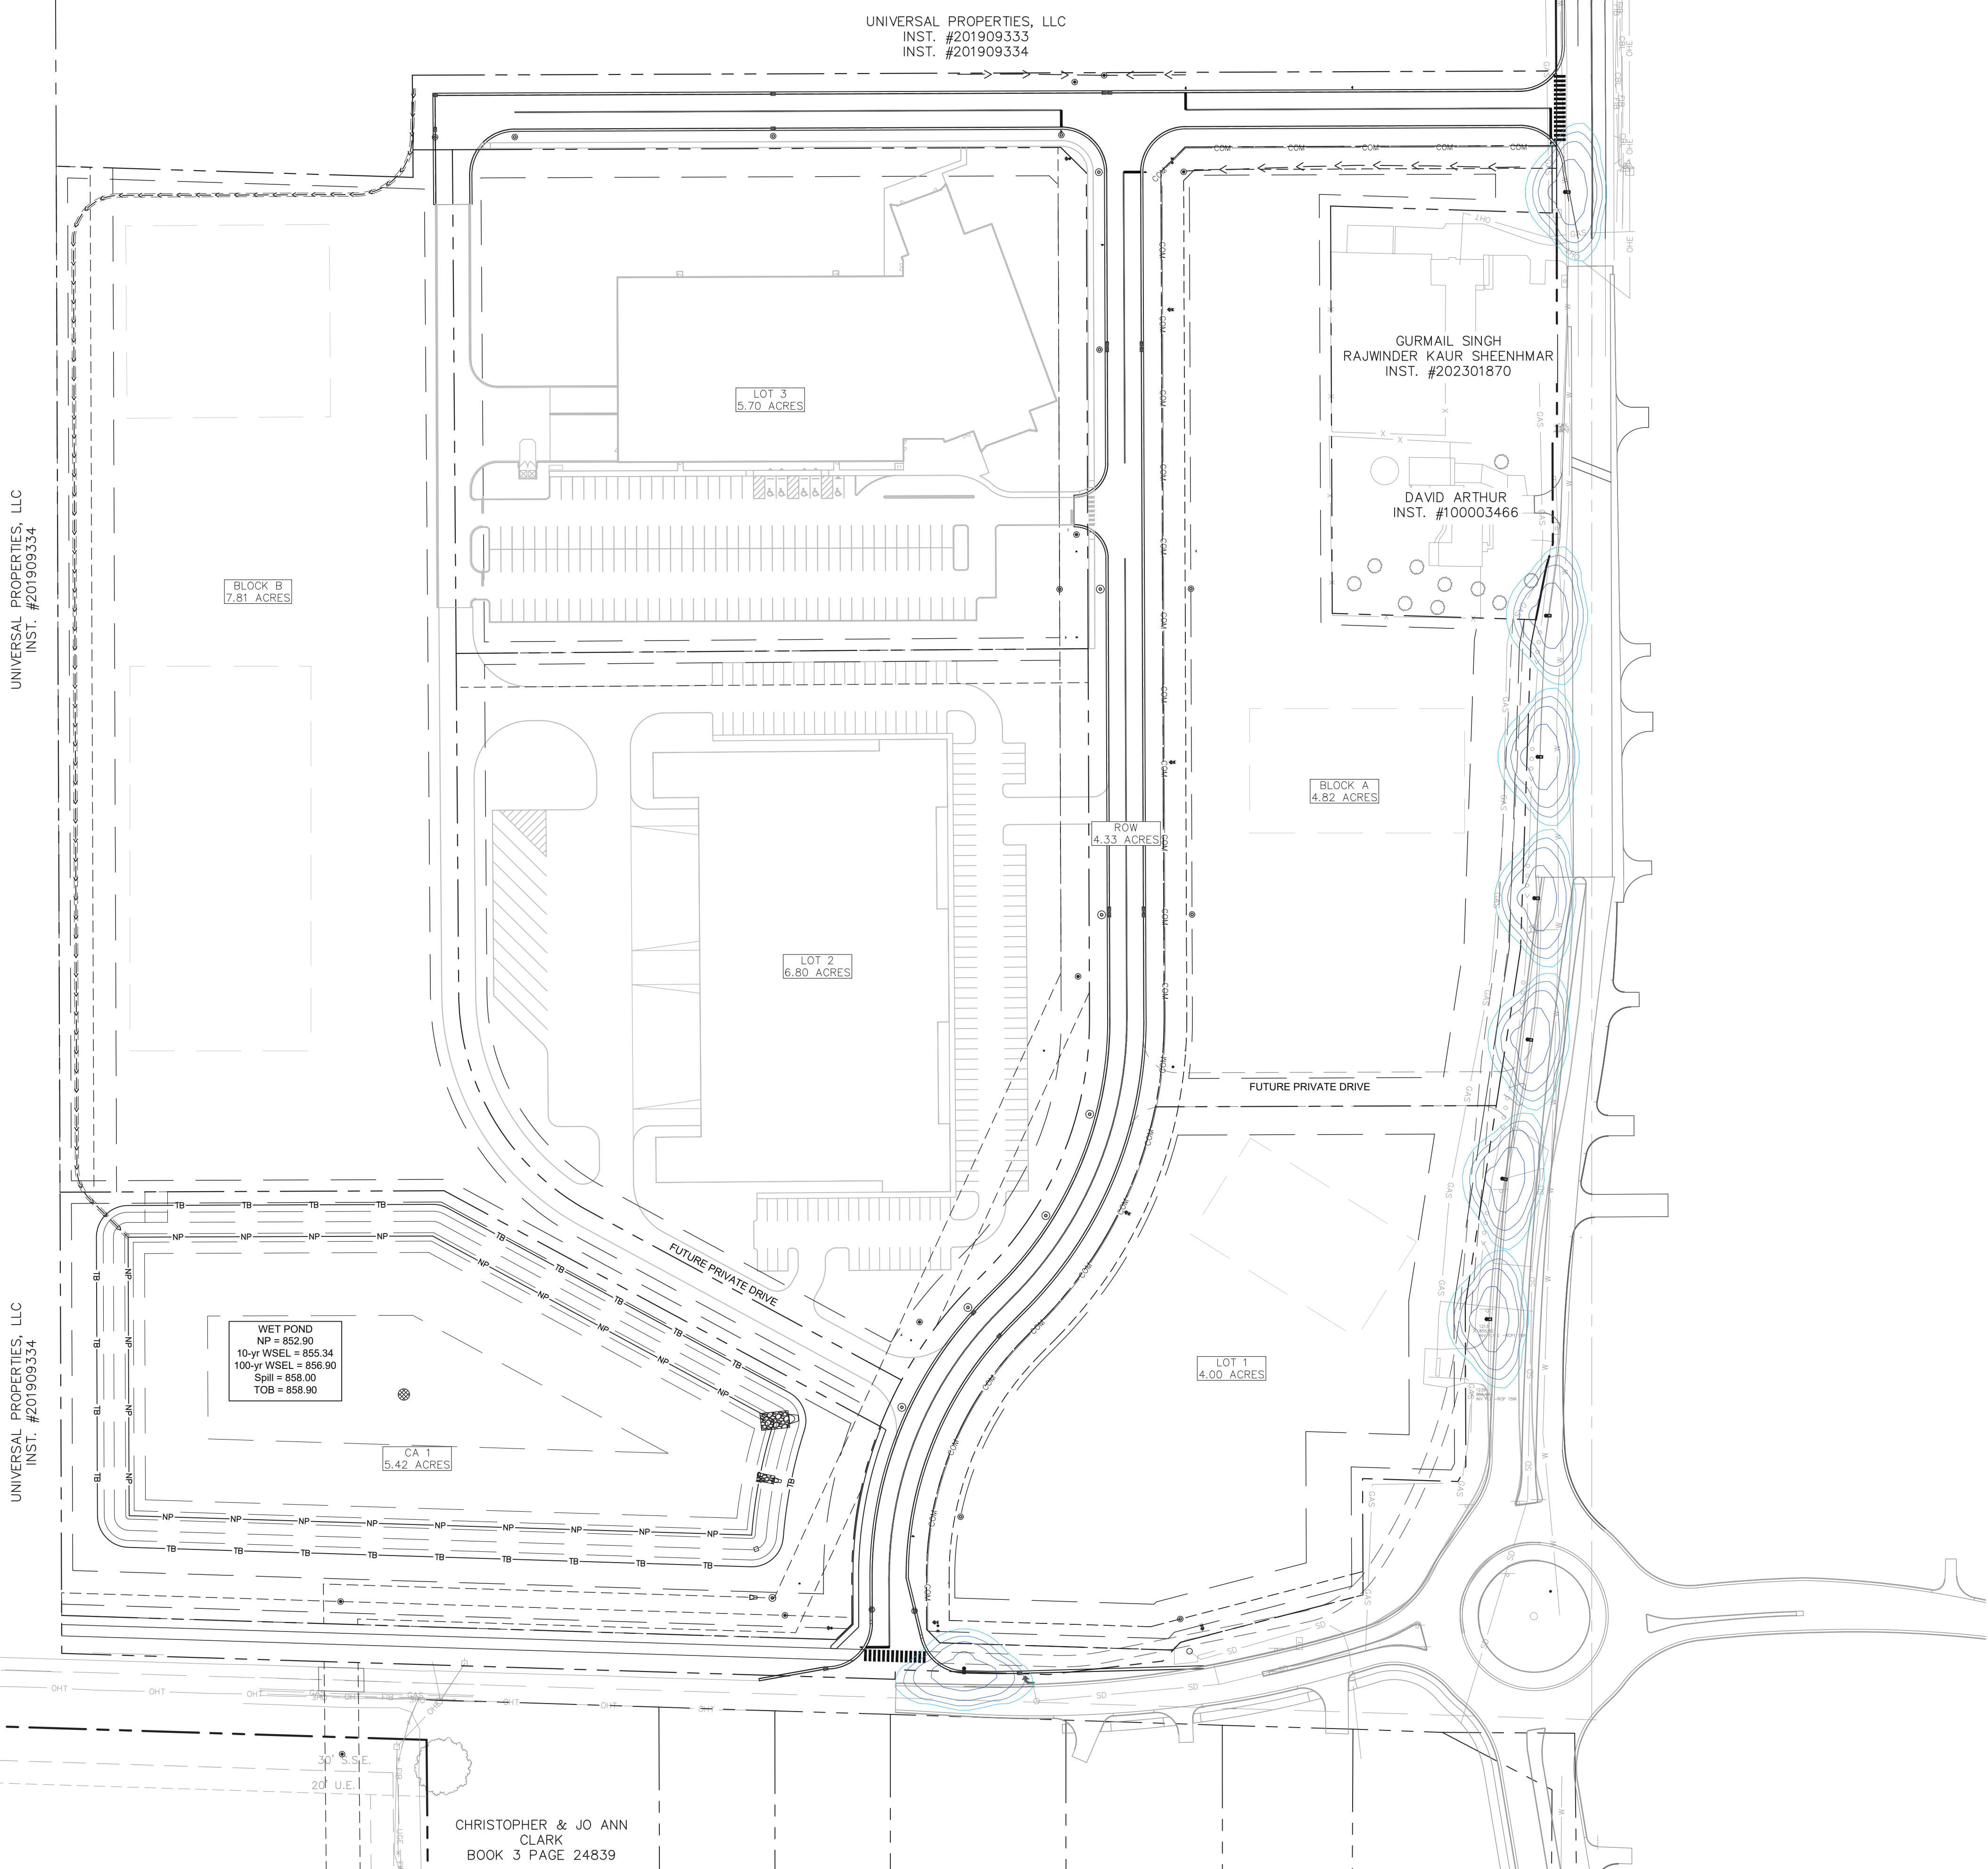

Indiana Utilities Protection Service

Call 811 

before you dig



GRAPHIC SCALE IN FEET

0 40 80 160



GATEWAY AT MCCORDSVILLE MASS GRADING & PUBLIC INFRASTRUCTURE NWC OF N 600 W & W 500 N, MCCORDSVILLE, IN 46055	CONCEPTUAL PHOTOMETRIC PLAN			Kimley»Horn ©2022 KIMLEY-HORN AND ASSOCIATES, INC. 300 EAST 96TH STREET, SUITE 300, INDIANAPOLIS, IN 46219 PHONE: 317-218-9560 WWW.KIMLEY-HORN.COM	SCALE: AS NOTED	☐	TAC COMMENTS	06/03/25	TNY
					DESIGNED BY: DJZ	☐			
					DRAWN BY: DJZ	☐			
					CHECKED BY: NPK	☐			
					No.	DATE			
ORIGINAL ISSUE: 05/02/2025 KHA PROJECT NO. 170125008 SHEET NUMBER P1.0									