




W BROADWAY ST & N CARROLL RD

*MCCORDSVILLE, IN 46055*



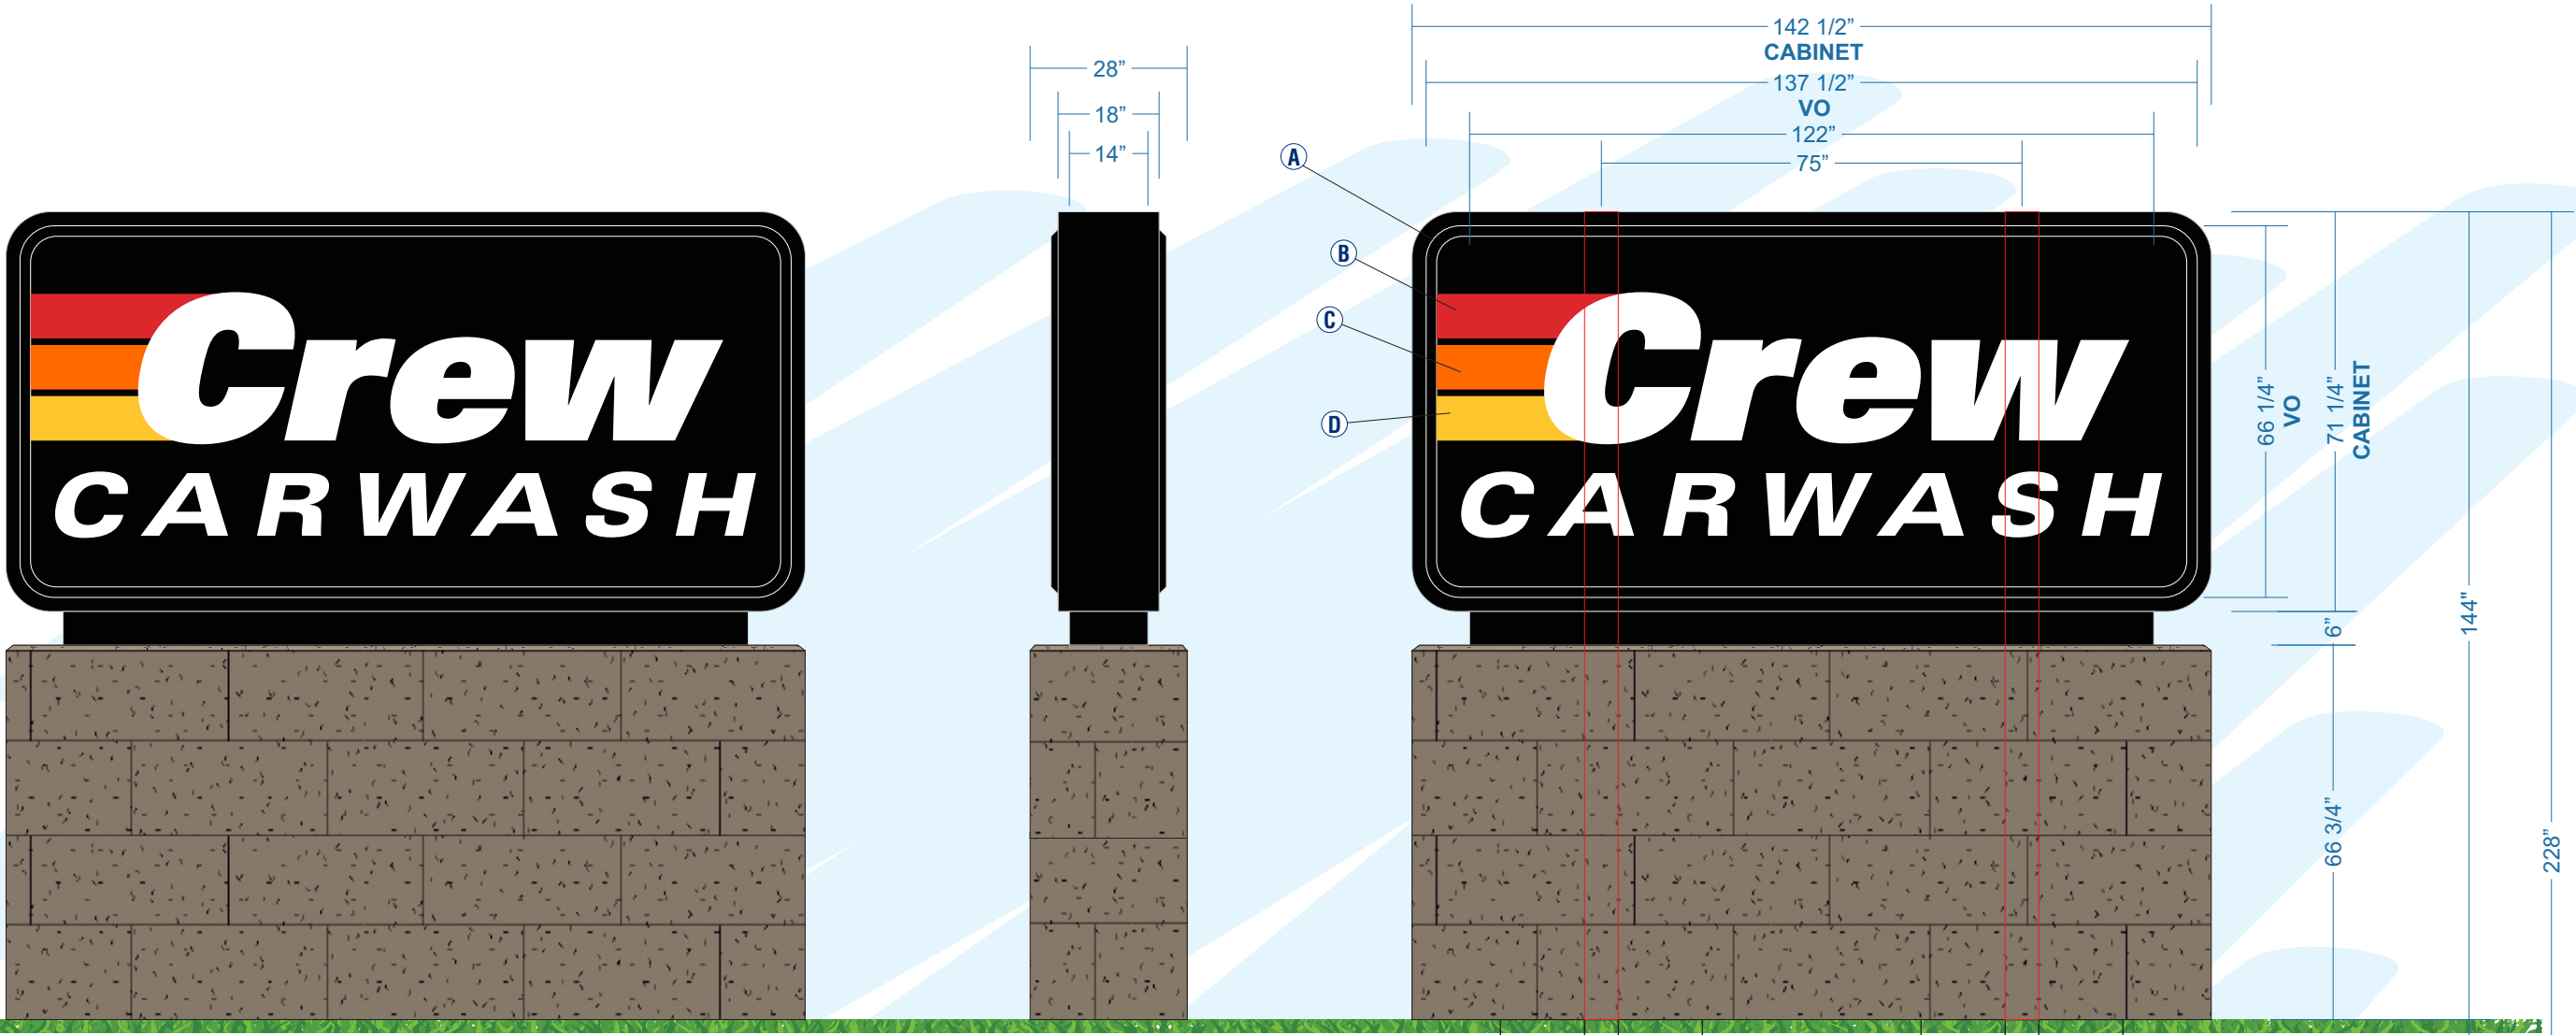

FABRICATE AND INSTALL QTY 1 INTERNALLY ILLUMINATED D/F GROUND SIGN

MAIN STRUCTURE

BODY - 2" ALUMINUM ANGLE SKINNED  
IN .090 ALUMINUM PAINTED TO MATCH SPECS

BASE

BODY - LIMESTONE MASONRY TO  
MATCH BUILDING TRIM

D/F TOP CABINET

BODY - 2" ALUMINUM ANGLE SKINNED IN  
.090 ALUMINUM PAINTED TO MATCH SPECS  
RADIUS - 8"  
VINYL - MATCH SPECS  
RETAINERS - 2" TO MATCH SPECS  
LEDS - WHITE

TOP CABINET FACES

MATERIAL - PAN FORMED, EMBOSSED  
PLASTIC TO MATCH SPECS  
FLANGE - 2 1/2"  
PAN DEPTH - 2"

EMCs (QTY 2)

RESOLUTION - 10MM  
COLOR - FULL COLOR

INSTALLATION - MAIN STRUCTURE AND BASE MOUNTED TO QTY 2 - 6" SCH 40 POLES, EMCS MOUNTED FLUSH TO MAIN STRUCTURE, TOP CABINET MOUNTED TO MAIN STRUCTURE & POLES, FACES INSTALLED INTO RETAINERS



COLOR SPECIFICATIONS:

A MP BLACK

B PMS 1795C RED

C PMS 1505C ORANGE

D PMS 123C YELLOW

E

F

G

H

I

J

NOTE: THERE WILL BE COLOR VARIATIONS FROM THIS PRINTED DRAWING TO THE FINAL PRODUCT. COLORS SPECIFIED WILL ALWAYS BE MATCHED AS CLOSELY AS POSSIBLE. RENDERING IS BASED ON ESTIMATED DIMENSIONS. A FINAL SURVEY MAY ALTER ILLUSTRATED REPRESENTATION AND PLACEMENT.

IF ILLUMINATED: WILL BE WIRED TO 120 VOLT UNLESS OTHERWISE SPECIFIED. THIS SIGN IS INTENDED TO BE INSTALLED IN ACCORDANCE WITH THE REQUIREMENTS OF ARTICLE 600 OF THE NATIONAL ELECTRICAL CODE AND/OR OTHER APPLICABLE LOCAL CODES. THIS INCLUDES PROPER GROUNDING AND BONDING OF THE SIGN.

SCI REP:  
CB

DATE:  
06/03/2022

DESIGNER:  
PB


REVISION DATE:

PERMIT INFORMATION:  
N/A

FINAL DATE & BY:

SHEET #:

1/11

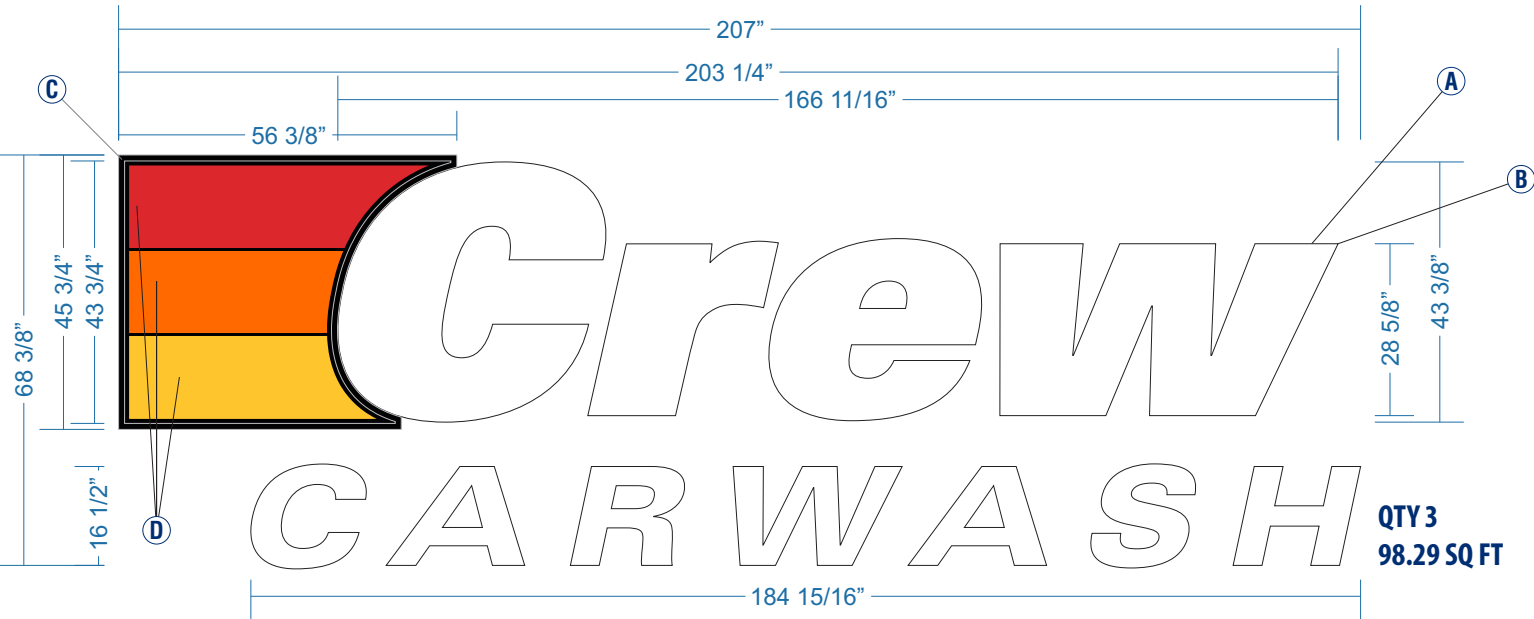

294.87 SQ FT  
FABRICATE AND INSTALL QTY 3 INTERNALLY ILLUMINATED FACE-LIT BUILDING SIGNS

**"CREW" & "CARWASH"**  
**FACES** - 1/8" 2447 WHITE ACRYLIC  
**RETURNS** - 5" TO MATCH SPECS  
**TRIM CAPS** - 1" TO MATCH SPECS  
**BACKS** - .063 ALUMINUM  
**LEDS** - WHITE

**INSTALLATION** - MOUNTED FLUSH TO FASCIA

**RIBBON CABINET**  
**BODY** - 1" ALUMINUM ANGLE SKINNED IN .090 ALUMINUM  
**RETURNS** - 5" TO MATCH SPECS  
**RETAINERS** - 1" RIGID RETAINERS TO MATCH SPECS  
**LEDS** - WHITE ECO-4

**INSTALLATION** - MOUNTED FLUSH TO FASCIA

**RIBBON FACES**  
**MATERIAL** - PAN FORMED, EMBOSSED PLASTIC PAINTED  
SECOND SURFACE TO MATCH SPECS  
**FLANGE** - 1 1/4"  
**PAN DEPTH** - 1"

**INSTALLATION** - MOUNTED INTO RIGID RETAINERS



SOUTH ELEVATION



WEST ELEVATION



NORTH ELEVATION

PHOTO SCALE: 1/16" = 1' - 0"



COLOR SPECIFICATIONS:

A BLACK RETURNS

B BLACK TRIM CAPS

C BLACK RETAINERS

D MATCH COLOR SAMPLE

E

F

G

H

I

J

NOTE: THERE WILL BE COLOR VARIATIONS FROM THIS PRINTED DRAWING TO THE FINAL PRODUCT. COLORS SPECIFIED WILL ALWAYS BE MATCHED AS CLOSELY AS POSSIBLE. RENDERING IS BASED ON ESTIMATED DIMENSIONS. A FINAL SURVEY MAY ALTER ILLUSTRATED REPRESENTATION AND PLACEMENT.

IF ILLUMINATED: WILL BE WIRED TO 120 VOLT UNLESS OTHERWISE SPECIFIED. THIS SIGN IS INTENDED TO BE INSTALLED IN ACCORDANCE WITH THE REQUIREMENTS OF ARTICLE 600 OF THE NATIONAL ELECTRICAL CODE AND/OR OTHER APPLICABLE LOCAL CODES. THIS INCLUDES PROPER GROUNDING AND BONDING OF THE SIGN.

SCI REP:  
CB

DATE:  
06/03/2022

DESIGNER:  
PB


REVISION DATE:  
07/29/2022 NK

PERMIT INFORMATION:  
N/A

FINAL DATE & BY:

SHEET #:

3/11

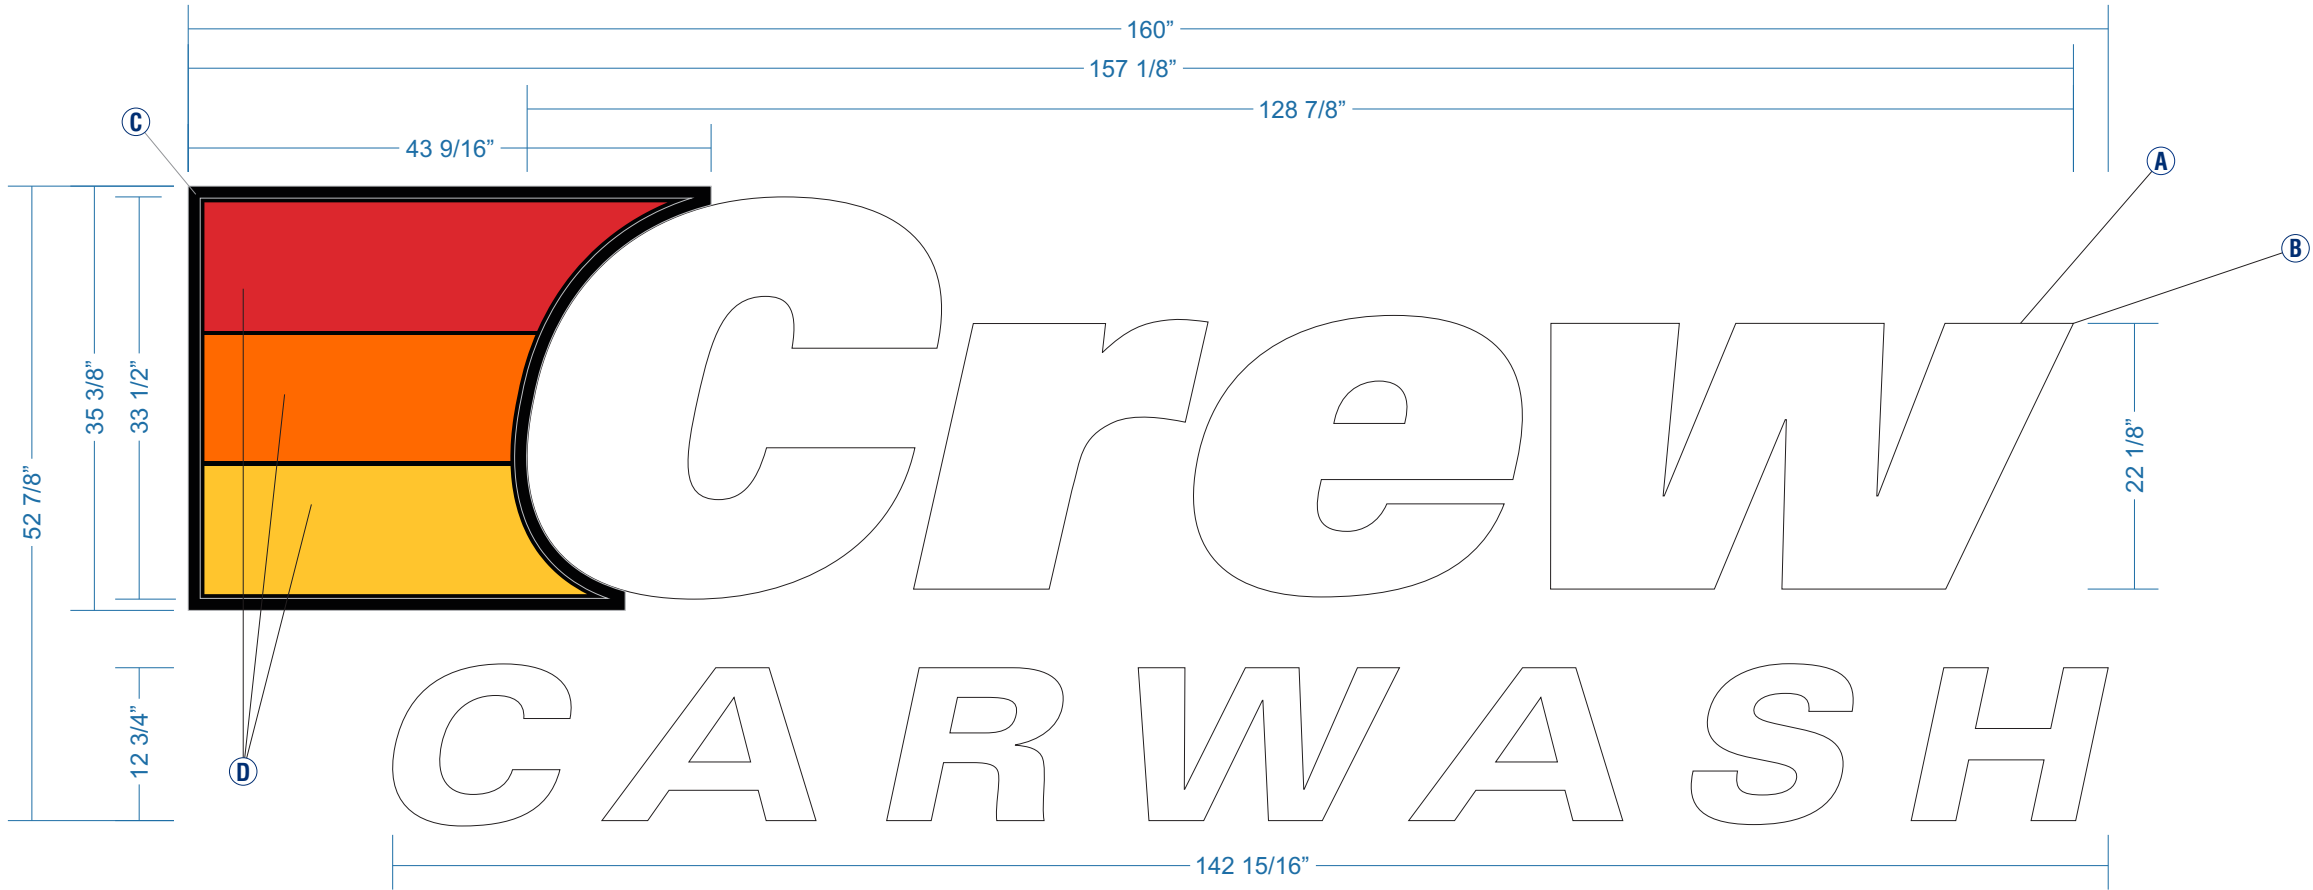

58.75 SQ FT  
FABRICATE AND INSTALL QTY 2 INTERNALLY ILLUMINATED FACE-LIT BUILDING SIGNS

**"CREW" & "CARWASH"**  
**FACES** - 1/8" 2447 WHITE ACRYLIC  
**RETURNS** - 5" TO MATCH SPECS  
**TRIM CAPS** - 1" TO MATCH SPECS  
**BACKS** - .063 ALUMINUM  
**LEDS** - WHITE

**INSTALLATION** - MOUNTED FLUSH TO FASCIA

**RIBBON CABINET**  
**BODY** - 1" ALUMINUM ANGLE SKINNED IN .090 ALUMINUM  
**RETURNS** - 5" TO MATCH SPECS  
**RETAINERS** - 1" RIGID RETAINERS TO MATCH SPECS  
**LEDS** - WHITE ECO-4

**INSTALLATION** - MOUNTED FLUSH TO FASCIA

**RIBBON FACES**  
**MATERIAL** - PAN FORMED, EMBOSSED PLASTIC PAINTED  
SECOND SURFACE TO MATCH SPECS  
**FLANGE** - 1 1/4"  
**PAN DEPTH** - 1"

**INSTALLATION** - MOUNTED INTO RIGID RETAINERS



WEST ELEVATION

PHOTO SCALE: 3/32" = 1' - 0"



COLOR SPECIFICATIONS:

- A BLACK RETURNS
- B BLACK TRIM CAPS
- C BLACK RETAINERS
- D MATCH COLOR SAMPLE
- E


- F
- G
- H
- I
- J

**NOTE:** THERE WILL BE COLOR VARIATIONS FROM THIS PRINTED DRAWING TO THE FINAL PRODUCT. COLORS SPECIFIED WILL ALWAYS BE MATCHED AS CLOSELY AS POSSIBLE. RENDERING IS BASED ON ESTIMATED DIMENSIONS. A FINAL SURVEY MAY ALTER ILLUSTRATED REPRESENTATION AND PLACEMENT.

**IF ILLUMINATED:** WILL BE WIRED TO 120 VOLT UNLESS OTHERWISE SPECIFIED. THIS SIGN IS INTENDED TO BE INSTALLED IN ACCORDANCE WITH THE REQUIREMENTS OF ARTICLE 600 OF THE NATIONAL ELECTRICAL CODE AND/OR OTHER APPLICABLE LOCAL CODES. THIS INCLUDES PROPER GROUNDING AND BONDING OF THE SIGN.

SCI REP: CB	DESIGNER: PB	PERMIT INFORMATION: N/A	
	REVISION DATE: 07/29/2022 NK	FINAL DATE & BY:	SHEET #: 2/11
DATE: 06/03/2022			



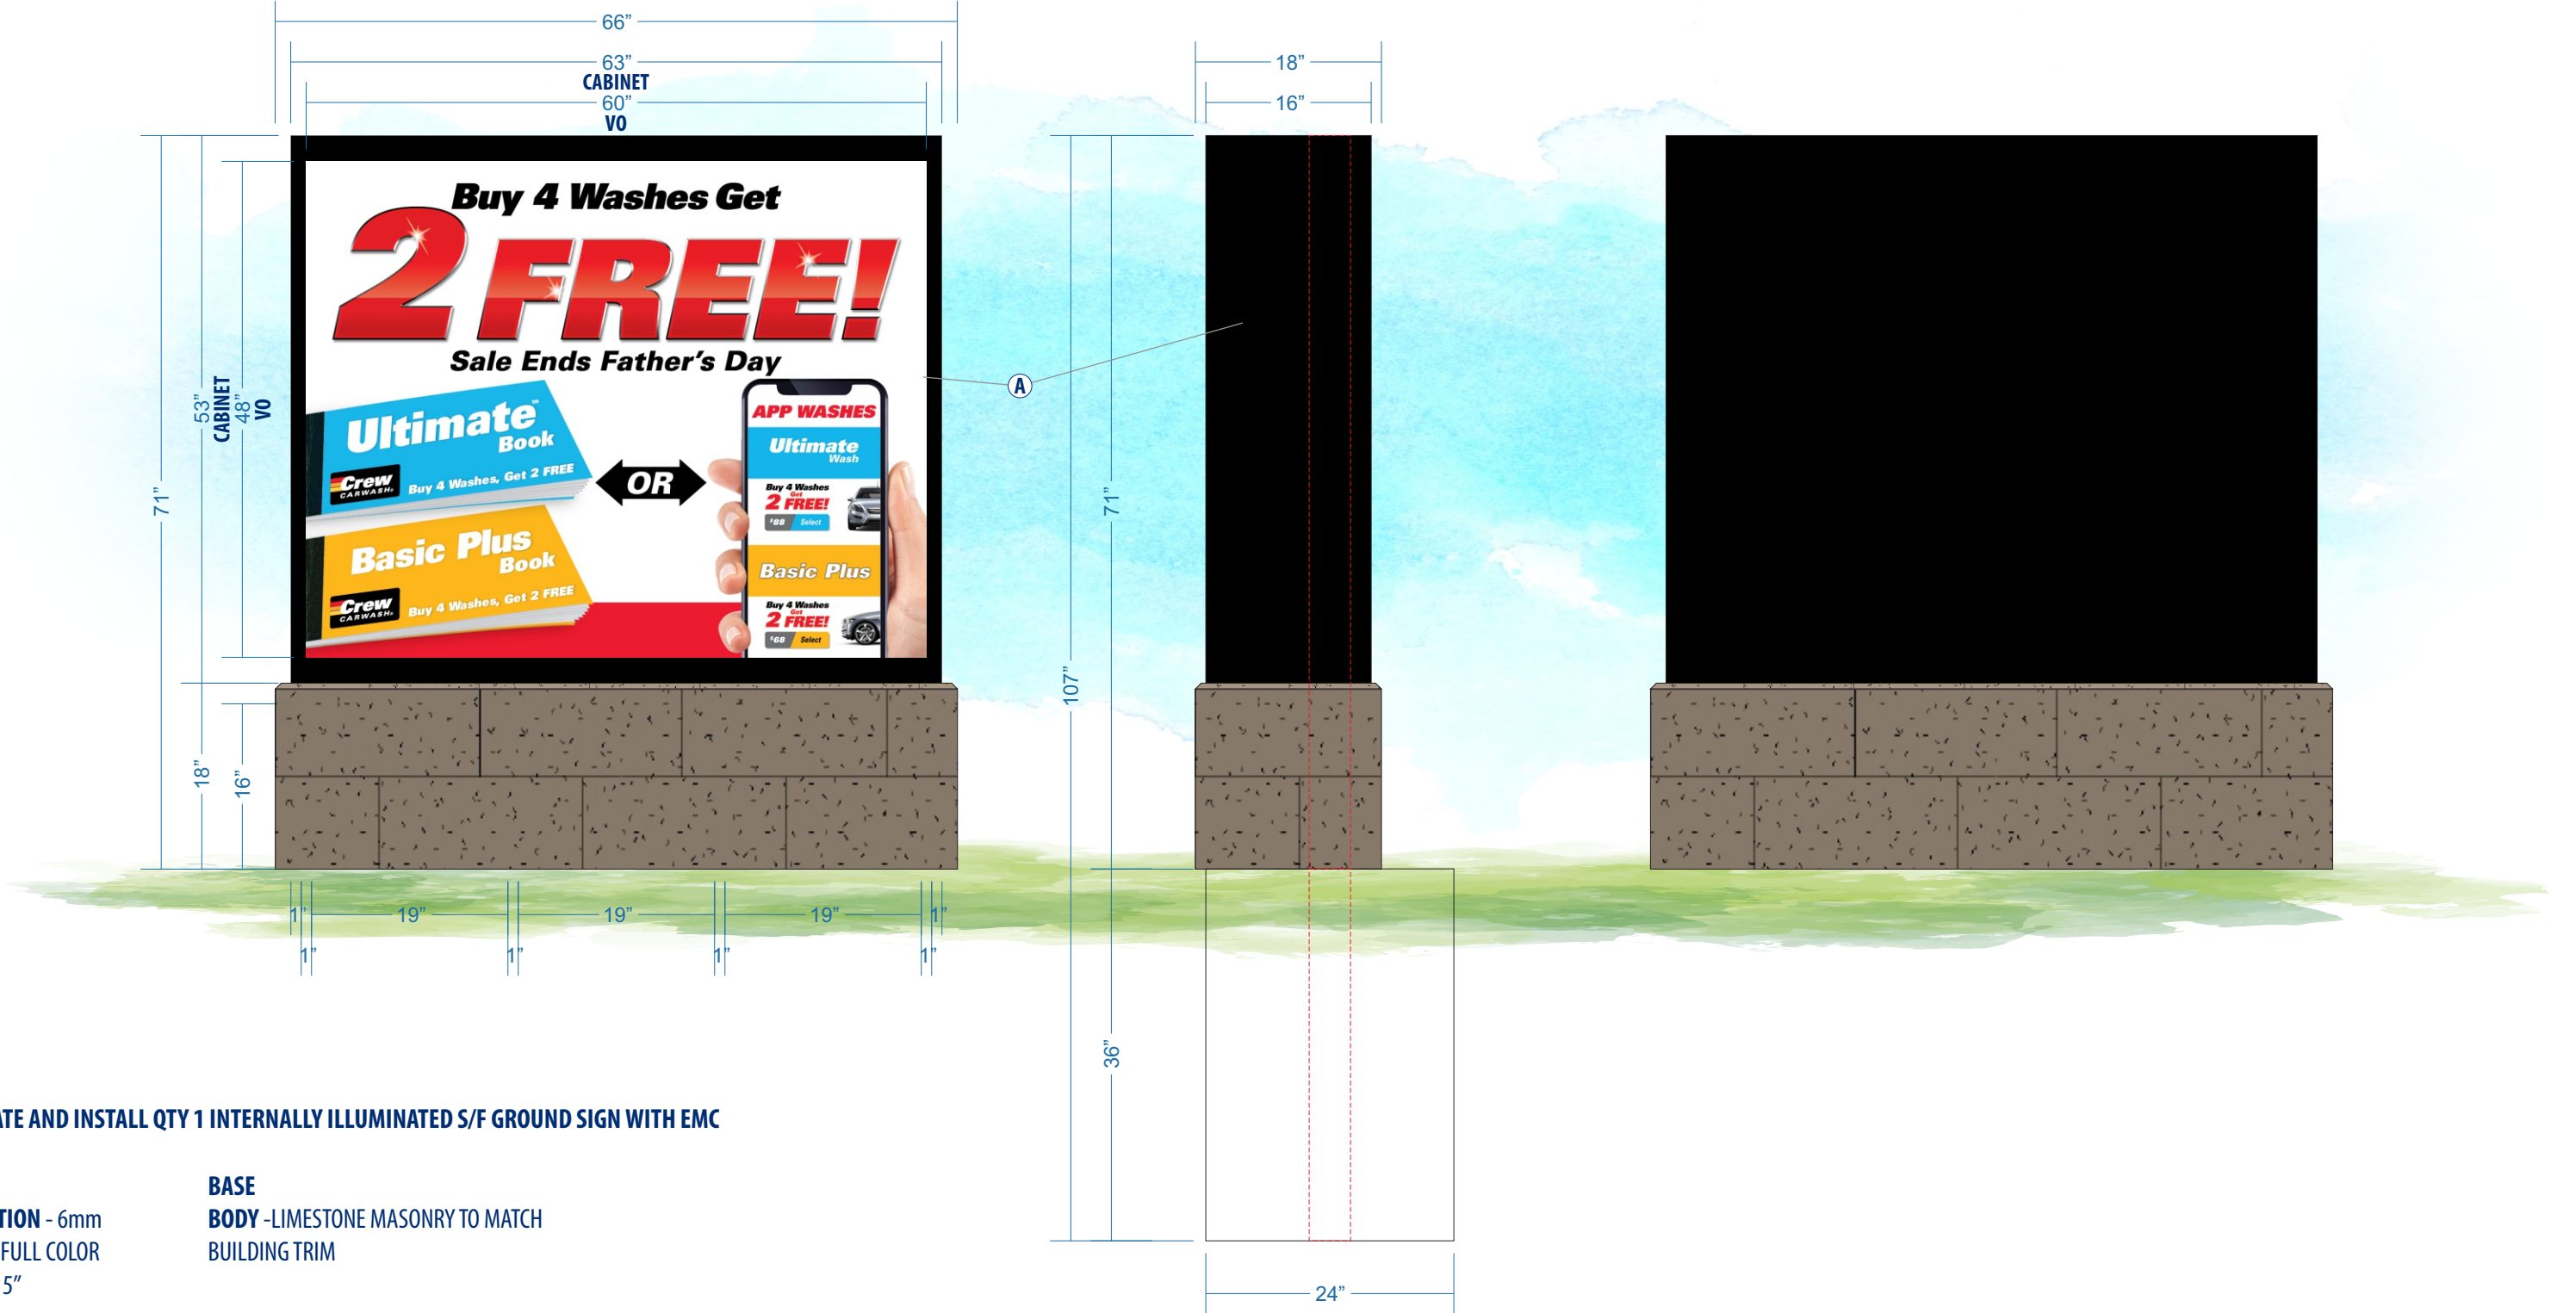

FABRICATE AND INSTALL QTY 1 INTERNALLY ILLUMINATED S/F GROUND SIGN WITH EMC

**EMC**

**RESOLUTION** - 6mm


**COLOR** - FULL COLOR






**DEPTH** - 5"

**BASE**

**BODY** - LIMESTONE MASONRY TO MATCH BUILDING TRIM

INSTALLATION - EMC MOUNTED TO MASONRY






**COLOR SPECIFICATIONS:**

A	MP BLACK	F	
B		G	
C		H	
D		I	
E		J	

*NOTE: THERE WILL BE COLOR VARIATIONS FROM THIS PRINTED DRAWING TO THE FINAL PRODUCT. COLORS SPECIFIED WILL ALWAYS BE MATCHED AS CLOSELY AS POSSIBLE. RENDERING IS BASED ON ESTIMATED DIMENSIONS. A FINAL SURVEY MAY ALTER ILLUSTRATED REPRESENTATION AND PLACEMENT.*

*IF ILLUMINATED: WILL BE WIRED TO 120 VOLT UNLESS OTHERWISE SPECIFIED. THIS SIGN IS INTENDED TO BE INSTALLED IN ACCORDANCE WITH THE REQUIREMENTS OF ARTICLE 600 OF THE NATIONAL ELECTRICAL CODE AND/OR OTHER APPLICABLE LOCAL CODES. THIS INCLUDES PROPER GROUNDING AND BONDING OF THE SIGN.*

<b>SCI REP:</b> CB	<b>DESIGNER:</b> PB	<b>PERMIT INFORMATION:</b> N/A	
<b>DATE:</b> 06/03/2022	<b>REVISION DATE:</b> 07/29/2022 PB	<b>FINAL DATE &amp; BY:</b>	<b>SHEET #:</b> 4/11

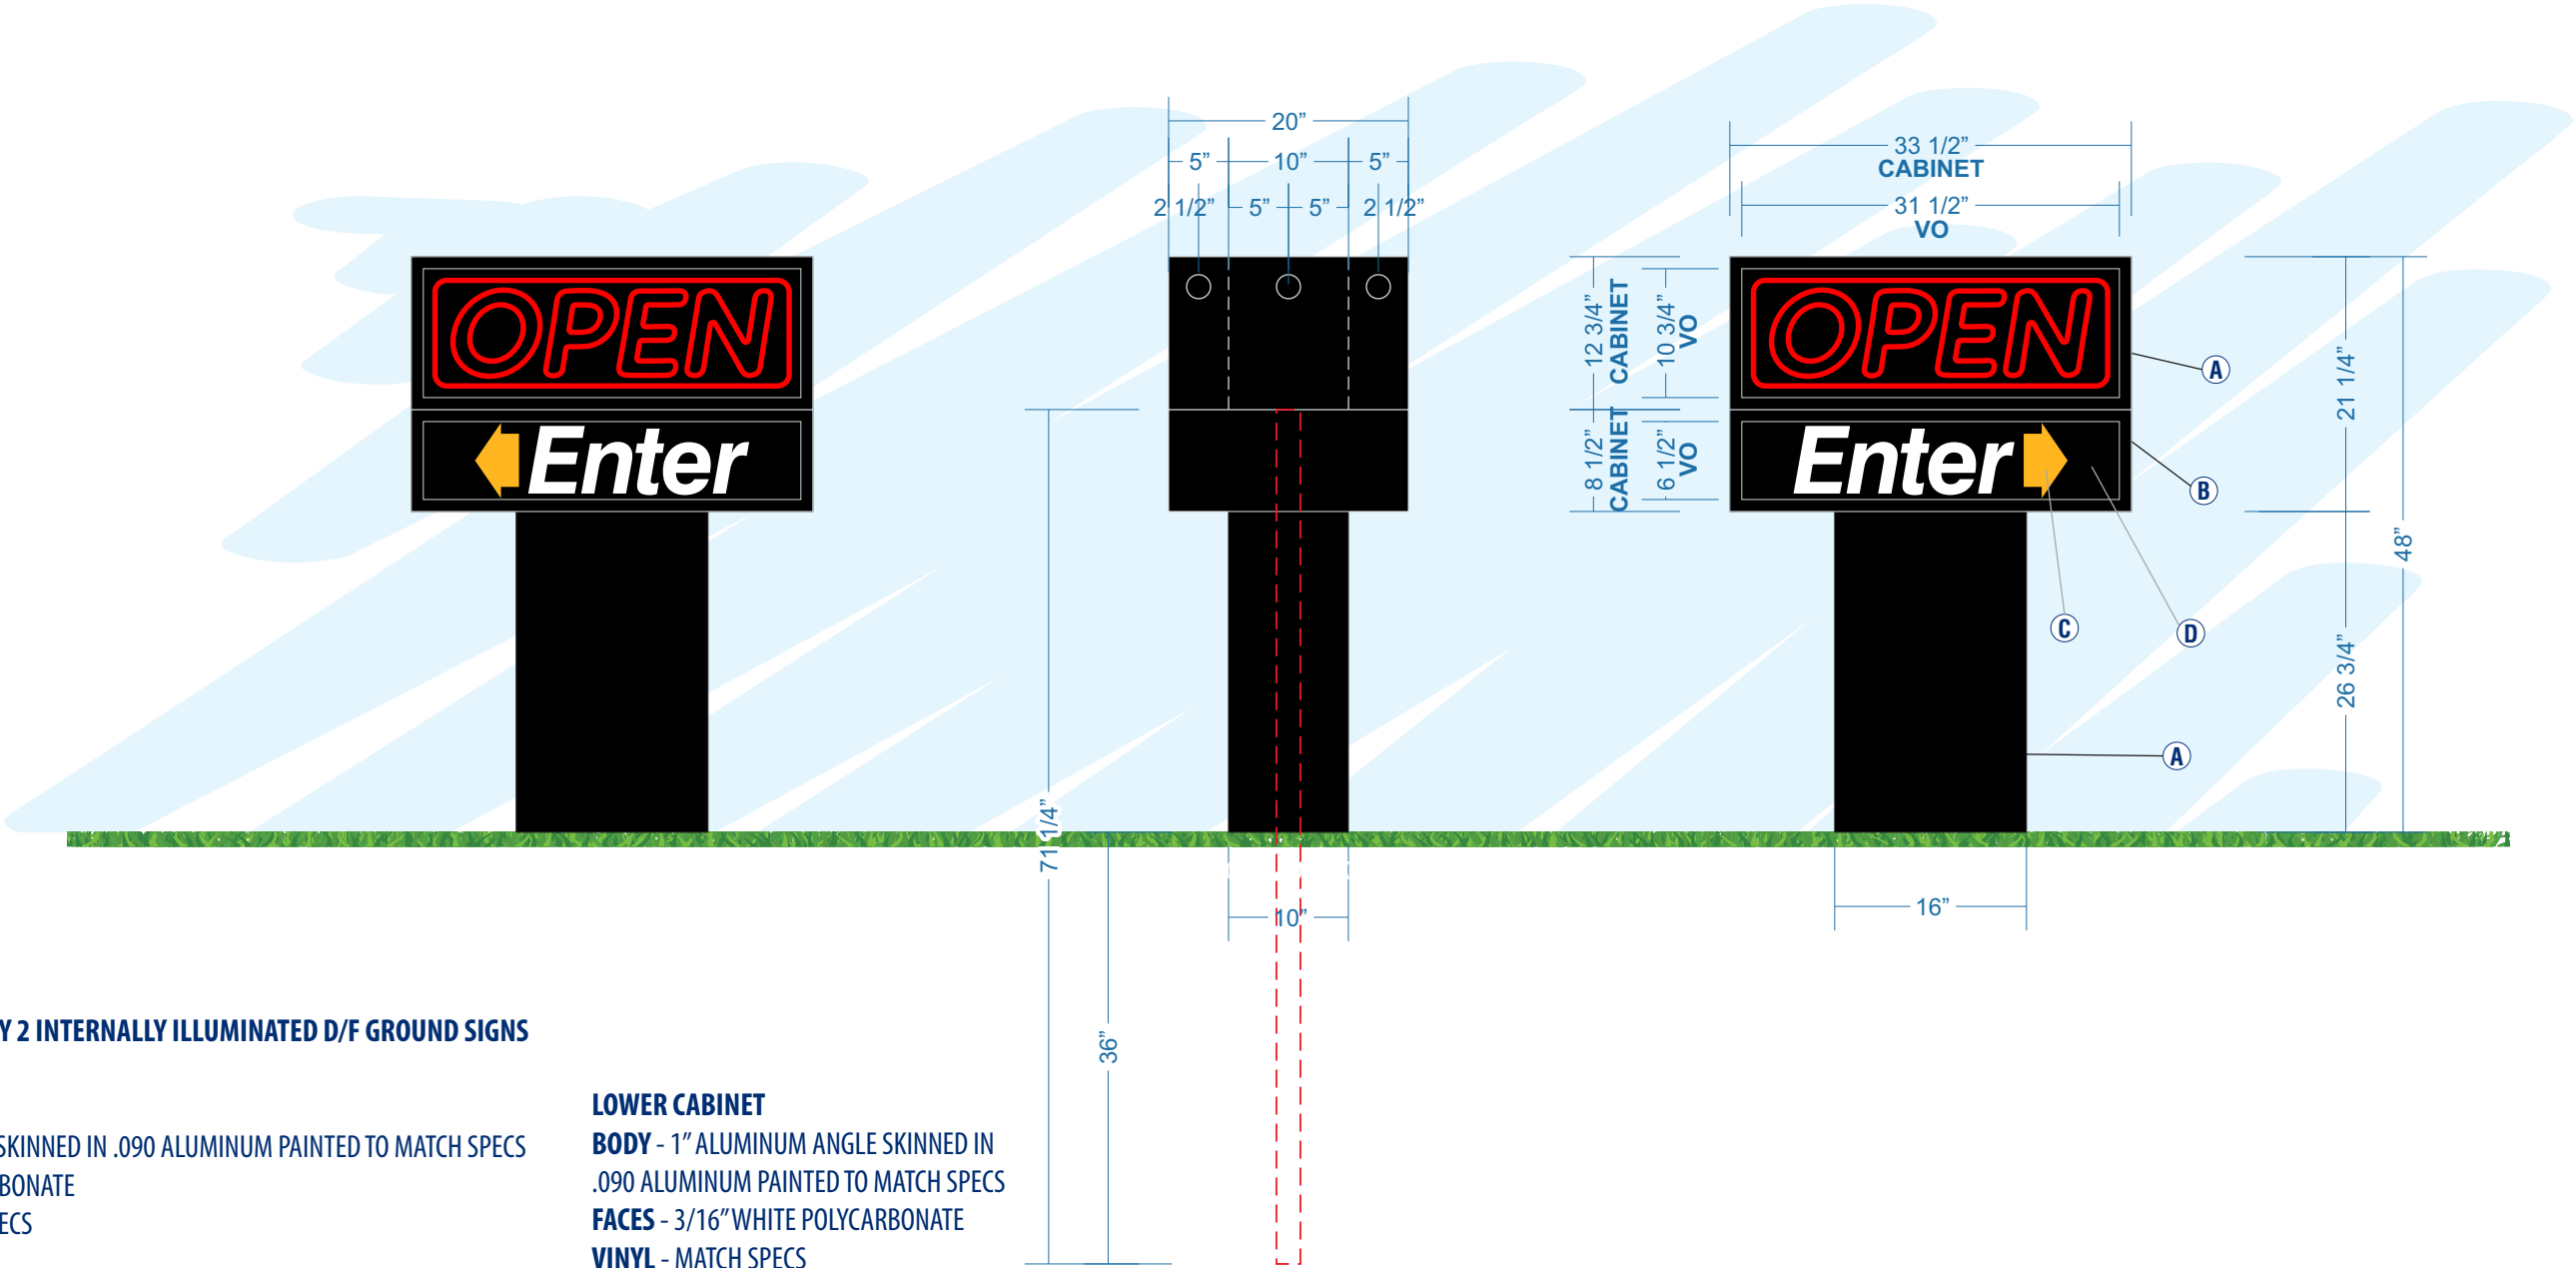

4.94 SQ FT  
FABRICATE AND INSTALL QTY 2 INTERNALLY ILLUMINATED D/F GROUND SIGNS

**UPPER CABINET**  
**BODY** - 1" ALUMINUM ANGLE SKINNED IN .090 ALUMINUM PAINTED TO MATCH SPECS  
**FACES** - 3/16" CLEAR POLYCARBONATE  
**RETAINERS** - 1" TO MATCH SPECS  
**NEON** - 12 MM RED

**INSTALLATION** - BAFFLE & DIVIDER NEEDED BETWEEN TOP AND BOTTOM CABINETS

**BASE**  
**BODY** - 1" ALUMINUM ANGLE SKINNED IN .090 ALUMINUM PAINTED TO MATCH SPECS

**INSTALLATION** - INSTALLED AROUND 2" SQ ALUMINUM POST BURIED INTO GRADE

**LOWER CABINET**  
**BODY** - 1" ALUMINUM ANGLE SKINNED IN .090 ALUMINUM PAINTED TO MATCH SPECS  
**FACES** - 3/16" WHITE POLYCARBONATE  
**VINYL** - MATCH SPECS  
**RETAINERS** - 1" TO MATCH SPECS

**INSTALLATION** - MOUNTED TO BASE & POST

COLOR SPECIFICATIONS:			
A	MP BLACK	F	
B	MP BLACK RETAINERS	G	
C	ORACAL 8500-020 GOLDEN YELLOW	H	
D	ORACAL 651-070 BLACK	I	
E		J	

*NOTE: THERE WILL BE COLOR VARIATIONS FROM THIS PRINTED DRAWING TO THE FINAL PRODUCT. COLORS SPECIFIED WILL ALWAYS BE MATCHED AS CLOSELY AS POSSIBLE. RENDERING IS BASED ON ESTIMATED DIMENSIONS. A FINAL SURVEY MAY ALTER ILLUSTRATED REPRESENTATION AND PLACEMENT.*

*IF ILLUMINATED: WILL BE WIRED TO 120 VOLT UNLESS OTHERWISE SPECIFIED. THIS SIGN IS INTENDED TO BE INSTALLED IN ACCORDANCE WITH THE REQUIREMENTS OF ARTICLE 600 OF THE NATIONAL ELECTRICAL CODE AND/OR OTHER APPLICABLE LOCAL CODES. THIS INCLUDES PROPER GROUNDING AND BONDING OF THE SIGN.*

SCI REP: CB	DESIGNER: PB	PERMIT INFORMATION: N/A	
	REVISION DATE: 07/29/2022 NK	FINAL DATE & BY:	SHEET #: 5/11
DATE: 06/03/2022			



10.94 SQ FT  
FABRICATE AND INSTALL NON-ILLUMINATED LETTERS

FACES - 1" WHITE PVC PAINTED TO MATCH SPECS  
VINYL - MATCH SPECS

INSTALLATION - MOUNTED FLUSH TO CANOPY

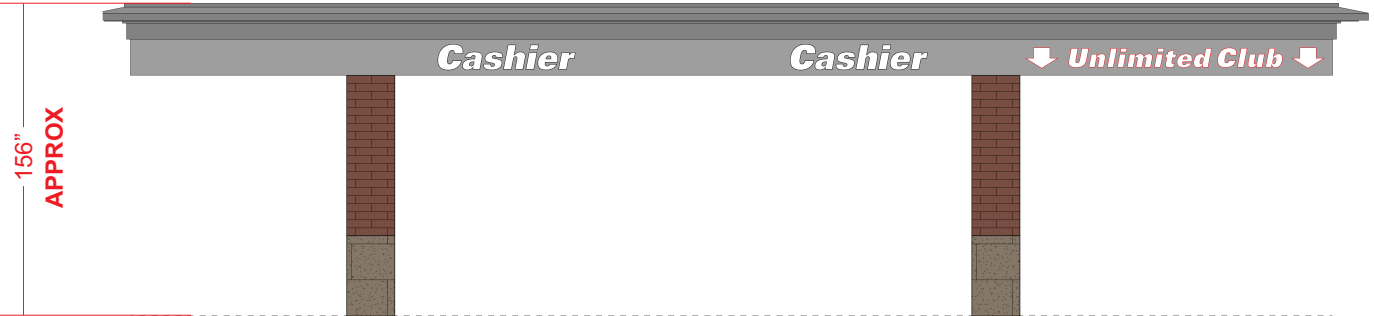


PHOTO SCALE: 1/8" = 1' - 0"


**COLOR SPECIFICATIONS:**

A	PMS 1795 C RED	F	
B	ORACAL 651-010 WHITE	G	
C		H	
D		I	
E		J	

**NOTE:** THERE WILL BE COLOR VARIATIONS FROM THIS PRINTED DRAWING TO THE FINAL PRODUCT. COLORS SPECIFIED WILL ALWAYS BE MATCHED AS CLOSELY AS POSSIBLE. RENDERING IS BASED ON ESTIMATED DIMENSIONS. A FINAL SURVEY MAY ALTER ILLUSTRATED REPRESENTATION AND PLACEMENT.

**IF ILLUMINATED:** WILL BE WIRED TO 120 VOLT UNLESS OTHERWISE SPECIFIED. THIS SIGN IS INTENDED TO BE INSTALLED IN ACCORDANCE WITH THE REQUIREMENTS OF ARTICLE 600 OF THE NATIONAL ELECTRICAL CODE AND/OR OTHER APPLICABLE LOCAL CODES. THIS INCLUDES PROPER GROUNDING AND BONDING OF THE SIGN.

<b>SCI REP:</b> CB	<b>DESIGNER:</b> PB	<b>PERMIT INFORMATION:</b> N/A	
<b>DATE:</b> 06/03/2022	<b>REVISION DATE:</b> 07/29/2022 NK	<b>FINAL DATE &amp; BY:</b>	<b>SHEET #:</b> 6/11

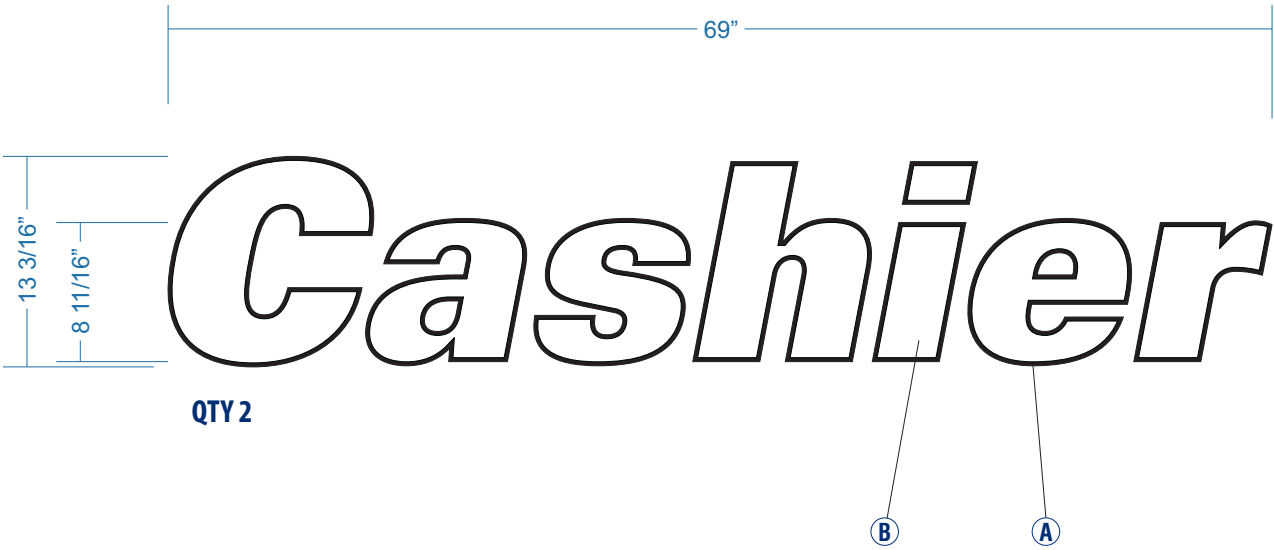

FABRICATE AND INSTALL QTY 2 NON-ILLUMINATED LETTERS SET

FACES - 1" WHITE PVC PAINTED TO MATCH SPECS  
VINYL - MATCH SPECS

INSTALLATION - MOUNTED FLUSH TO CANOPY

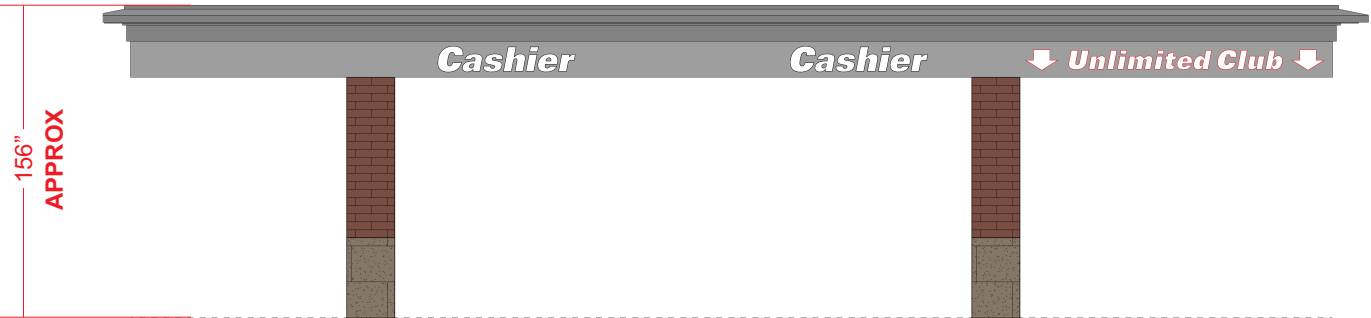







PHOTO SCALE: 1/8" = 1' - 0"





COLOR SPECIFICATIONS:


A	MP BLACK	F	
B	ORACAL 651-010 WHITE	G	
C		H	
D		I	
E		J	

*NOTE: THERE WILL BE COLOR VARIATIONS FROM THIS PRINTED DRAWING TO THE FINAL PRODUCT. COLORS SPECIFIED WILL ALWAYS BE MATCHED AS CLOSELY AS POSSIBLE. RENDERING IS BASED ON ESTIMATED DIMENSIONS. A FINAL SURVEY MAY ALTER ILLUSTRATED REPRESENTATION AND PLACEMENT.*

*IF ILLUMINATED: WILL BE WIRED TO 120 VOLT UNLESS OTHERWISE SPECIFIED. THIS SIGN IS INTENDED TO BE INSTALLED IN ACCORDANCE WITH THE REQUIREMENTS OF ARTICLE 600 OF THE NATIONAL ELECTRICAL CODE AND/OR OTHER APPLICABLE LOCAL CODES. THIS INCLUDES PROPER GROUNDING AND BONDING OF THE SIGN.*

SCI REP: CB	DESIGNER: PB	PERMIT INFORMATION: N/A	
DATE: 06/03/2022	REVISION DATE: 07/29/2022 NK	FINAL DATE & BY:	SHEET #: 7/11



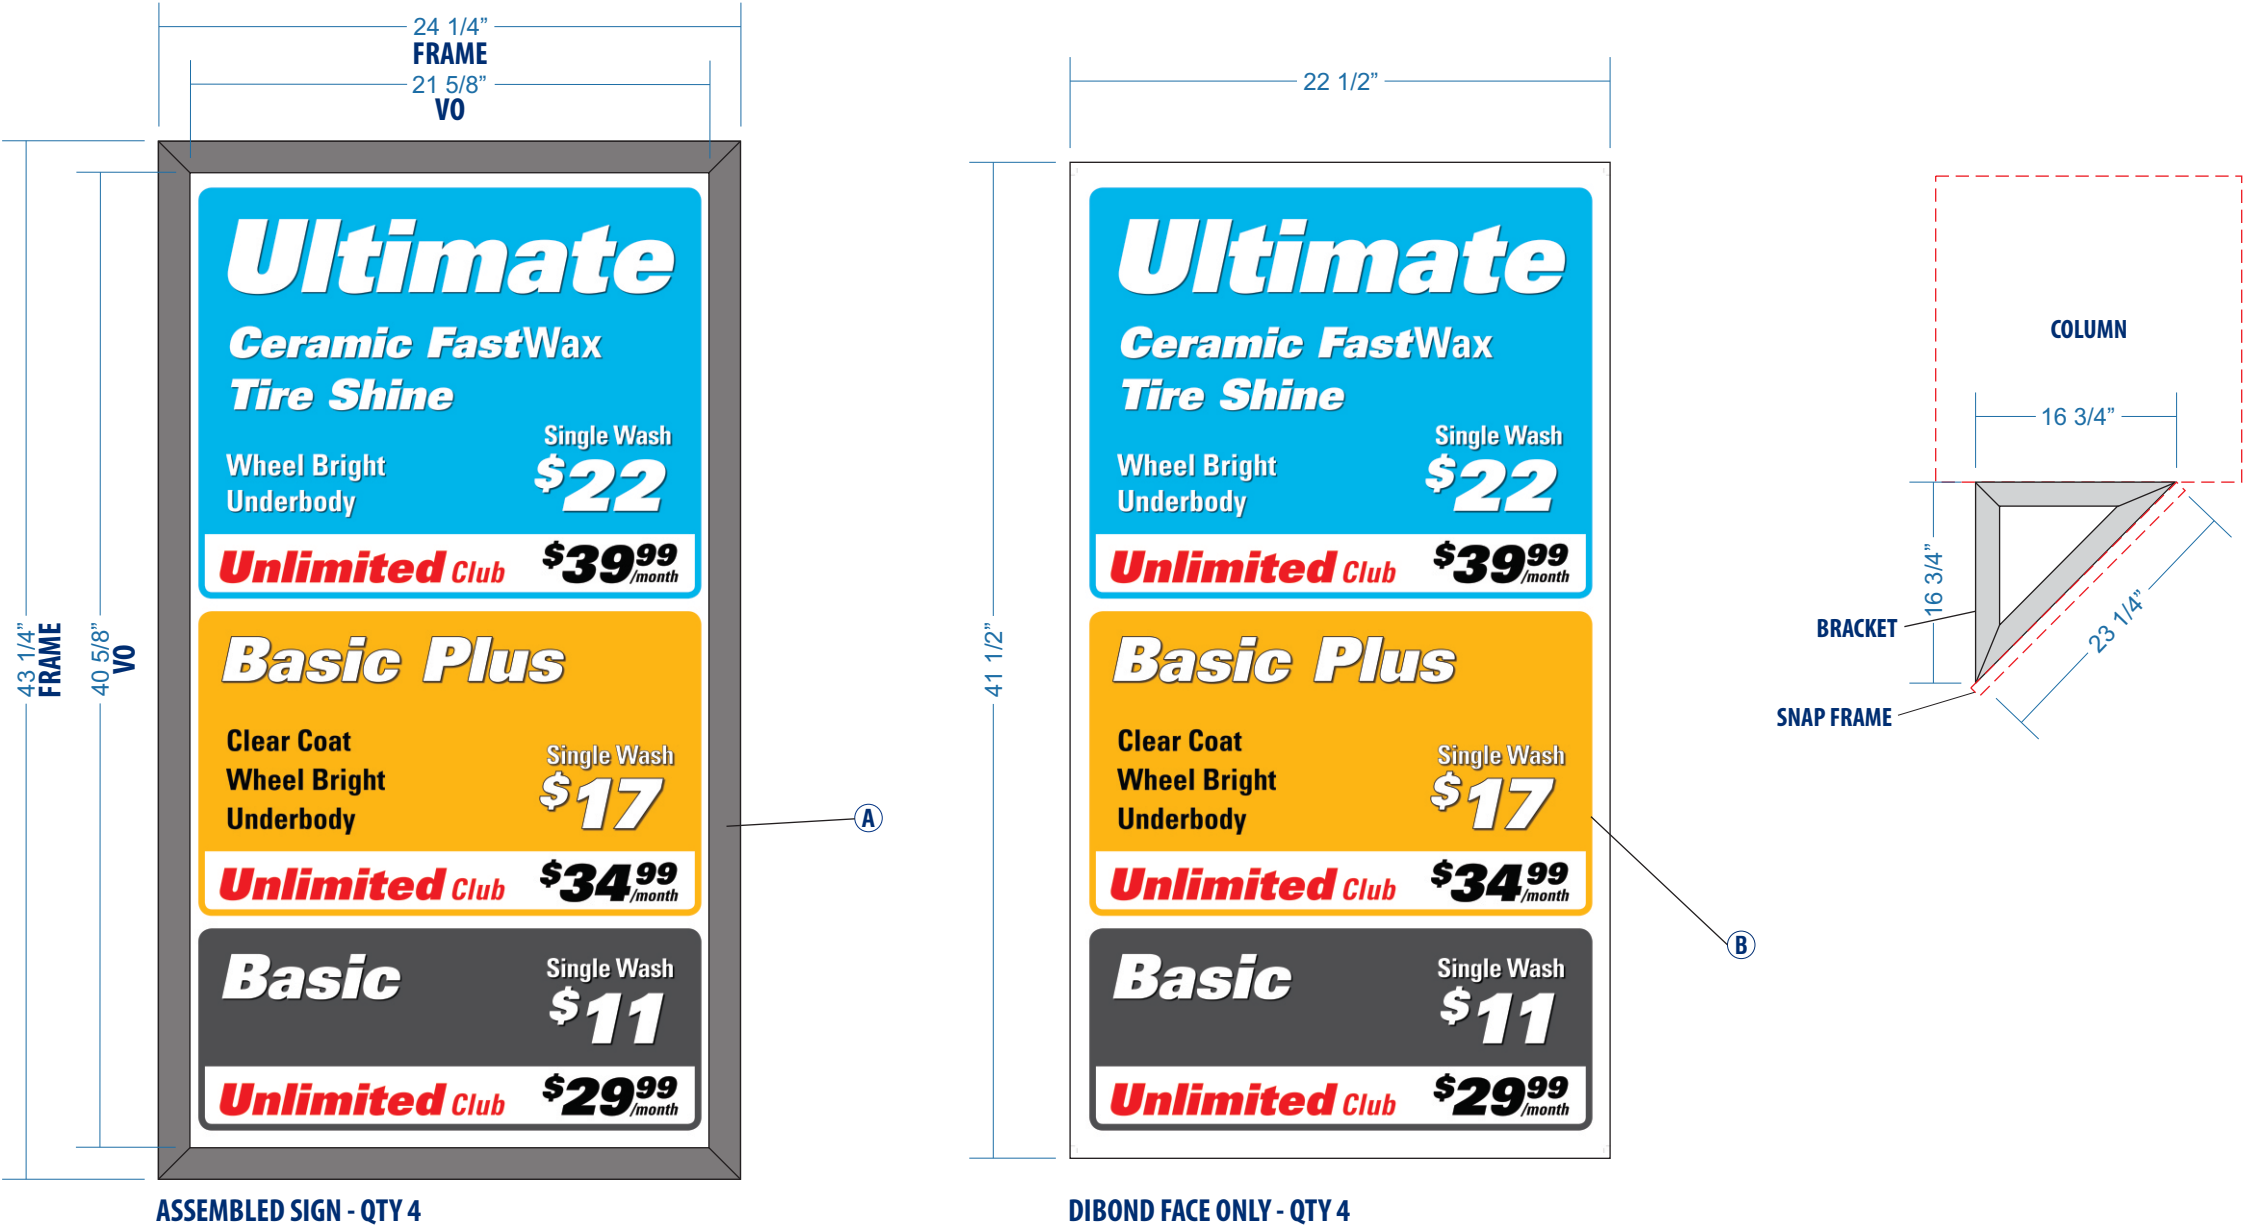

FABRICATE AND INSTALL QTY 4 SNAP FRAMES

**BODY**  
SIGN COMP KIT - 1899 & 1869A PAINTED TO MATCH SPECS


**INSTALLATION** - QTY 2 FRAMES FLUSH MOUNTED TO COLUMNS, QTY 2 FRAMES ANGLED OFF COLUMNS

**FACES**  
MATERIAL - 3MM WHITE DIBOND  
VINYL - MATCH SPECS

**INSTALLATION** - MOUNTED INTO SNAP FRAMES

**ANGLED BRACKETS**  
BODY - 2" ALUMINUM ANGLE

**INSTALLATION** - MOUNTED TO SNAP FRAME AND COLUMN

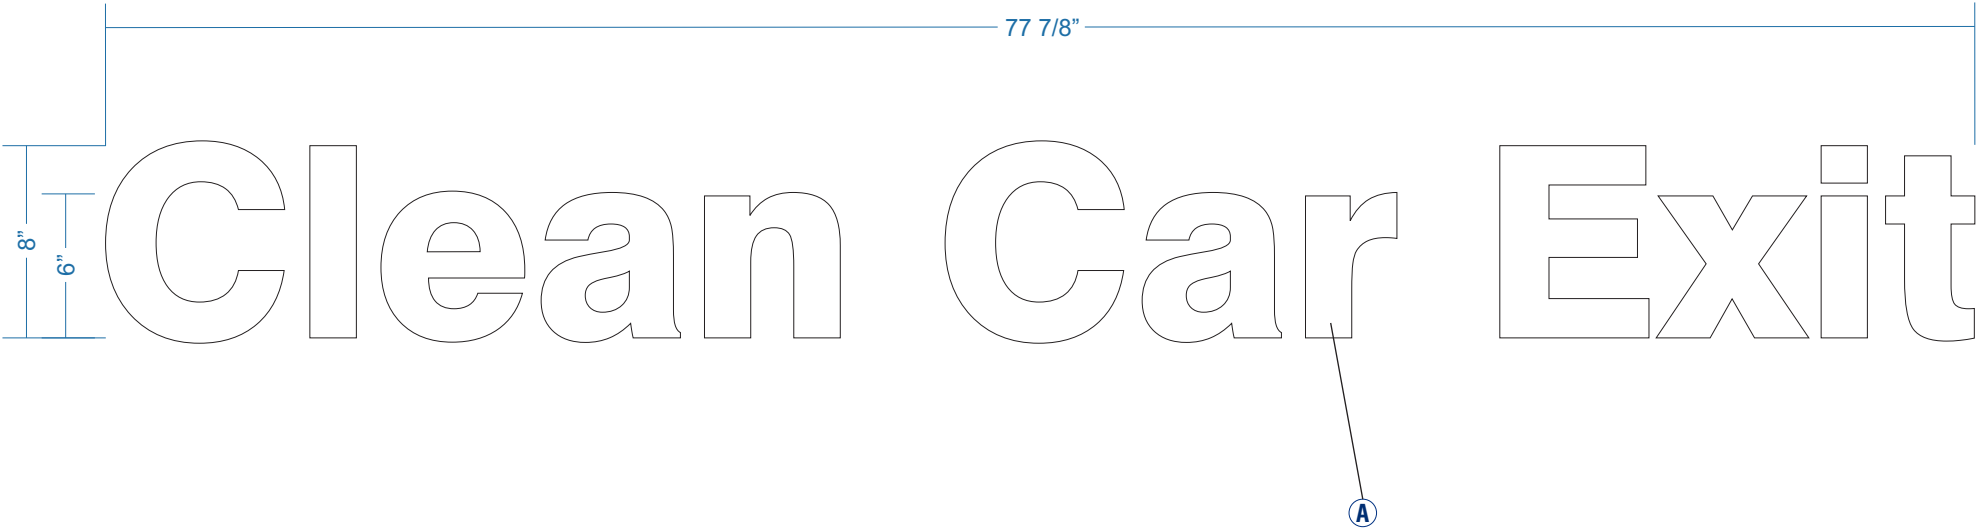

FABRICATE AND INSTALL NON-ILLUMINATED LETTERS


FACES - 1" WHITE PVC PAINTED TO MATCH SPECS






INSTALLATION - MOUNTED FLUSH TO FASCIA



WEST ELEVATION

PHOTO SCALE: 3/32" = 1' - 0"






COLOR SPECIFICATIONS:

A	MP WHITE	F	
B		G	
C		H	
D		I	
E		J	

*NOTE: THERE WILL BE COLOR VARIATIONS FROM THIS PRINTED DRAWING TO THE FINAL PRODUCT. COLORS SPECIFIED WILL ALWAYS BE MATCHED AS CLOSELY AS POSSIBLE. RENDERING IS BASED ON ESTIMATED DIMENSIONS. A FINAL SURVEY MAY ALTER ILLUSTRATED REPRESENTATION AND PLACEMENT.*

*IF ILLUMINATED: WILL BE WIRED TO 120 VOLT UNLESS OTHERWISE SPECIFIED. THIS SIGN IS INTENDED TO BE INSTALLED IN ACCORDANCE WITH THE REQUIREMENTS OF ARTICLE 600 OF THE NATIONAL ELECTRICAL CODE AND/OR OTHER APPLICABLE LOCAL CODES. THIS INCLUDES PROPER GROUNDING AND BONDING OF THE SIGN.*

SCI REP: CB	DESIGNER: PB	PERMIT INFORMATION: N/A	
DATE: 06/03/2022	REVISION DATE: 07/29/2022 NK	FINAL DATE & BY:	SHEET #: 9/11

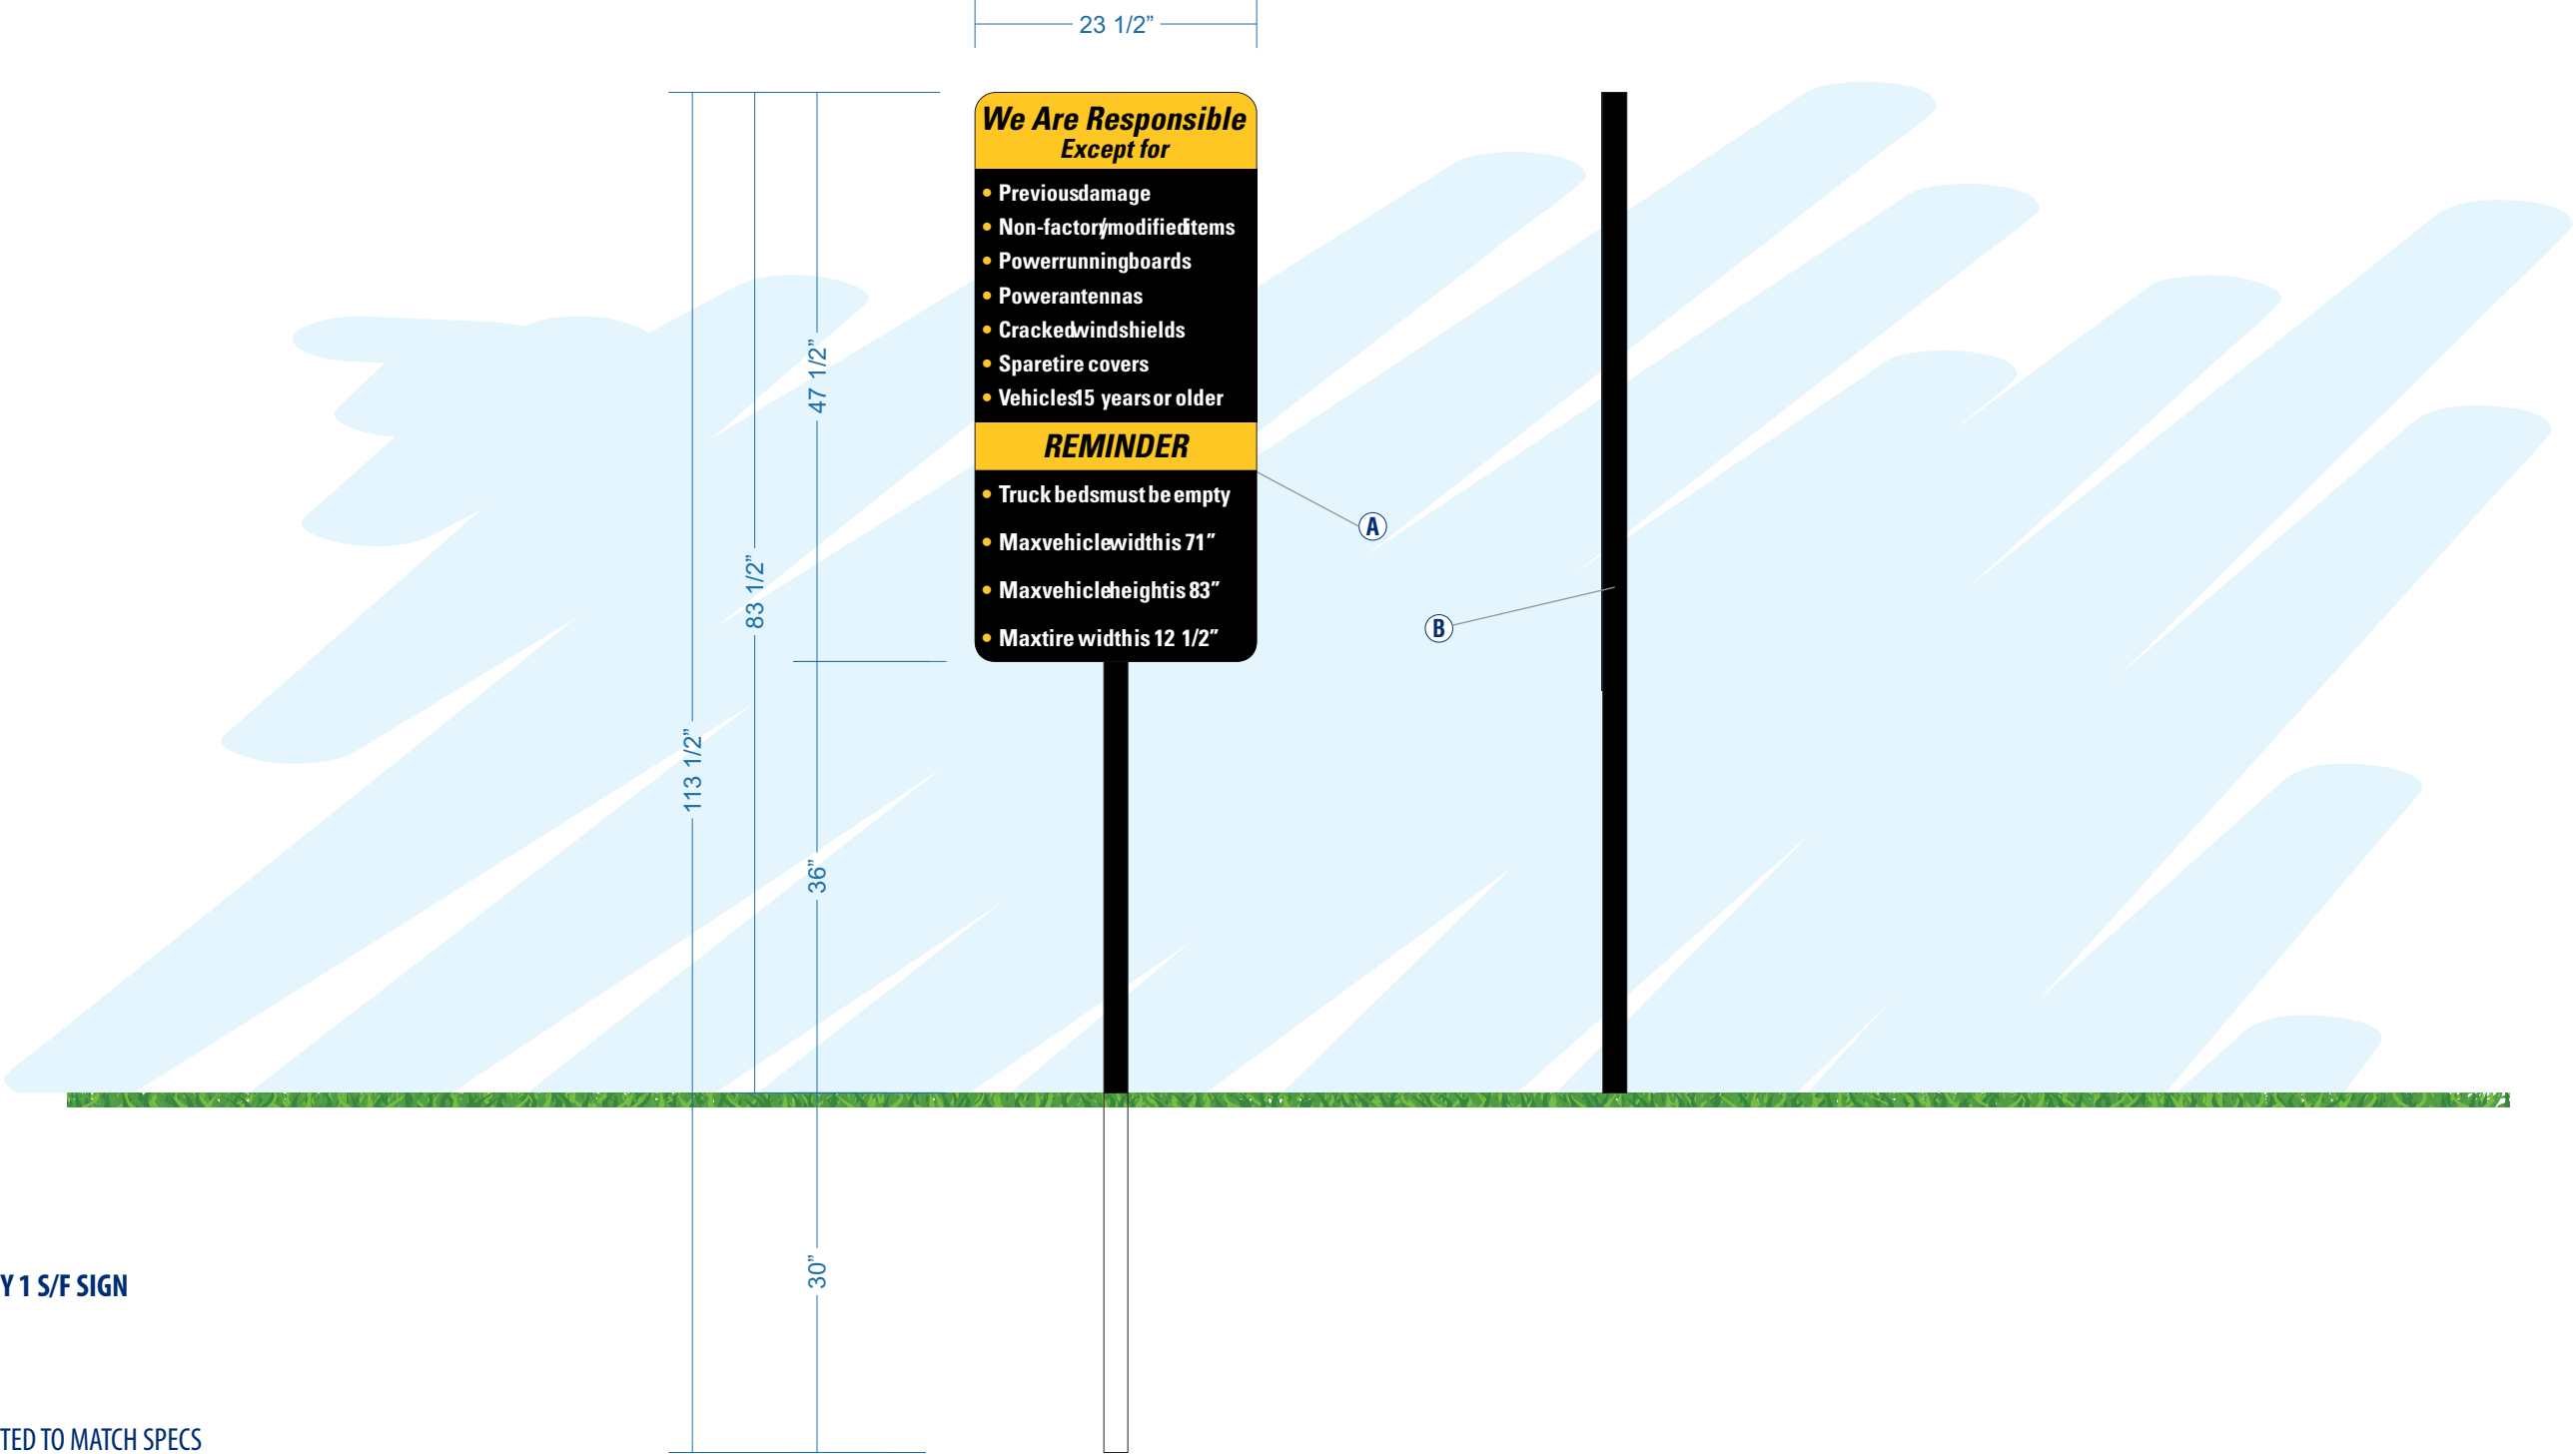


FABRICATE AND INSTALL QTY 1 S/F SIGN






FACES - 3MM BLACK DIBOND

VINYL - MATCH SPECS

POST - 2" SQ ALUMINUM PAINTED TO MATCH SPECS

INSTALLATION - FACE MOUNTED TO POST, POST BURIED INTO GRADE





COLOR SPECIFICATIONS:

A

MP BLACK

B

DIG. PRINT

C

D

E

F

G

H

I

J

NOTE: THERE WILL BE COLOR VARIATIONS FROM THIS PRINTED DRAWING TO THE FINAL PRODUCT. COLORS SPECIFIED WILL ALWAYS BE MATCHED AS CLOSELY AS POSSIBLE. RENDERING IS BASED ON ESTIMATED DIMENSIONS. A FINAL SURVEY MAY ALTER ILLUSTRATED REPRESENTATION AND PLACEMENT.

IF ILLUMINATED: WILL BE WIRED TO 120 VOLT UNLESS OTHERWISE SPECIFIED. THIS SIGN IS INTENDED TO BE INSTALLED IN ACCORDANCE WITH THE REQUIREMENTS OF ARTICLE 600 OF THE NATIONAL ELECTRICAL CODE AND/OR OTHER APPLICABLE LOCAL CODES. THIS INCLUDES PROPER GROUNDING AND BONDING OF THE SIGN.

SCI REP:

CB

DATE:

06/03/2022

DESIGNER:

PB

REVISION DATE:

07/29/2022 NK


PERMIT INFORMATION:

N/A

FINAL DATE & BY:

SHEET #:


10/11

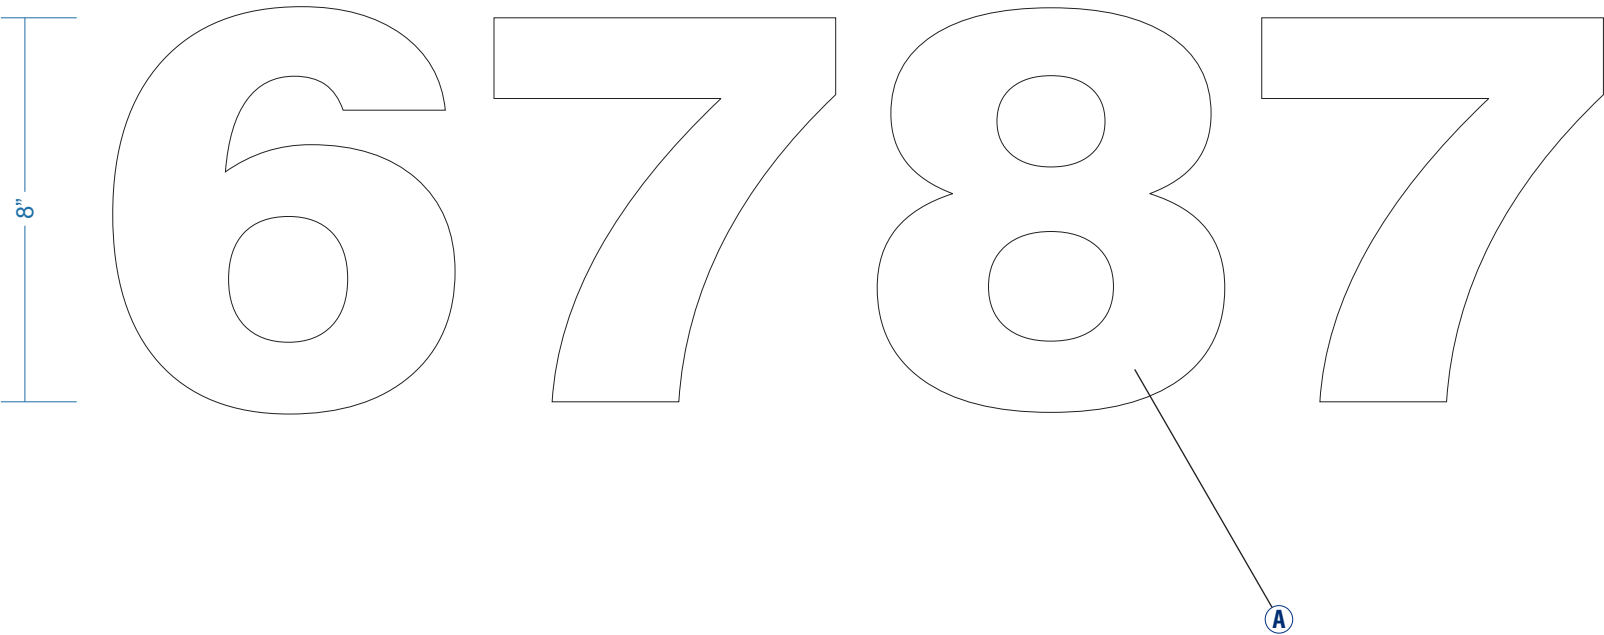





FABRICATE AND INSTALL QTY 1 PVC NUMBERS

FACES - 1" WHITE PVC PAINTED TO MATCH SPECS

INSTALLATION - MOUNTED FLUSH TO FASCIA (BUILDING LOCATION TBD)





COLOR SPECIFICATIONS:

A

MP WHITE

B

C

D

E

F

G

H

I

J

NOTE: THERE WILL BE COLOR VARIATIONS FROM THIS PRINTED DRAWING TO THE FINAL PRODUCT. COLORS SPECIFIED WILL ALWAYS BE MATCHED AS CLOSELY AS POSSIBLE. RENDERING IS BASED ON ESTIMATED DIMENSIONS. A FINAL SURVEY MAY ALTER ILLUSTRATED REPRESENTATION AND PLACEMENT.

IF ILLUMINATED: WILL BE WIRED TO 120 VOLT UNLESS OTHERWISE SPECIFIED. THIS SIGN IS INTENDED TO BE INSTALLED IN ACCORDANCE WITH THE REQUIREMENTS OF ARTICLE 600 OF THE NATIONAL ELECTRICAL CODE AND/OR OTHER APPLICABLE LOCAL CODES. THIS INCLUDES PROPER GROUNDING AND BONDING OF THE SIGN.

SCI REP: CB	DESIGNER: PB	PERMIT INFORMATION: N/A	
DATE: 06/03/2022	REVISION DATE: 07/29/2022 NK	FINAL DATE & BY:	SHEET #: 11/11

© 2020 - SIGNCRAFT INDUSTRIES ALL RIGHTS RESERVED • 8816 CORPORATION DR • INDIANAPOLIS, INDIANA 46256 • 317-842-8664 • SIGNCRAFTIND.COM

ART SCALE: 3" = 1' - 0"