



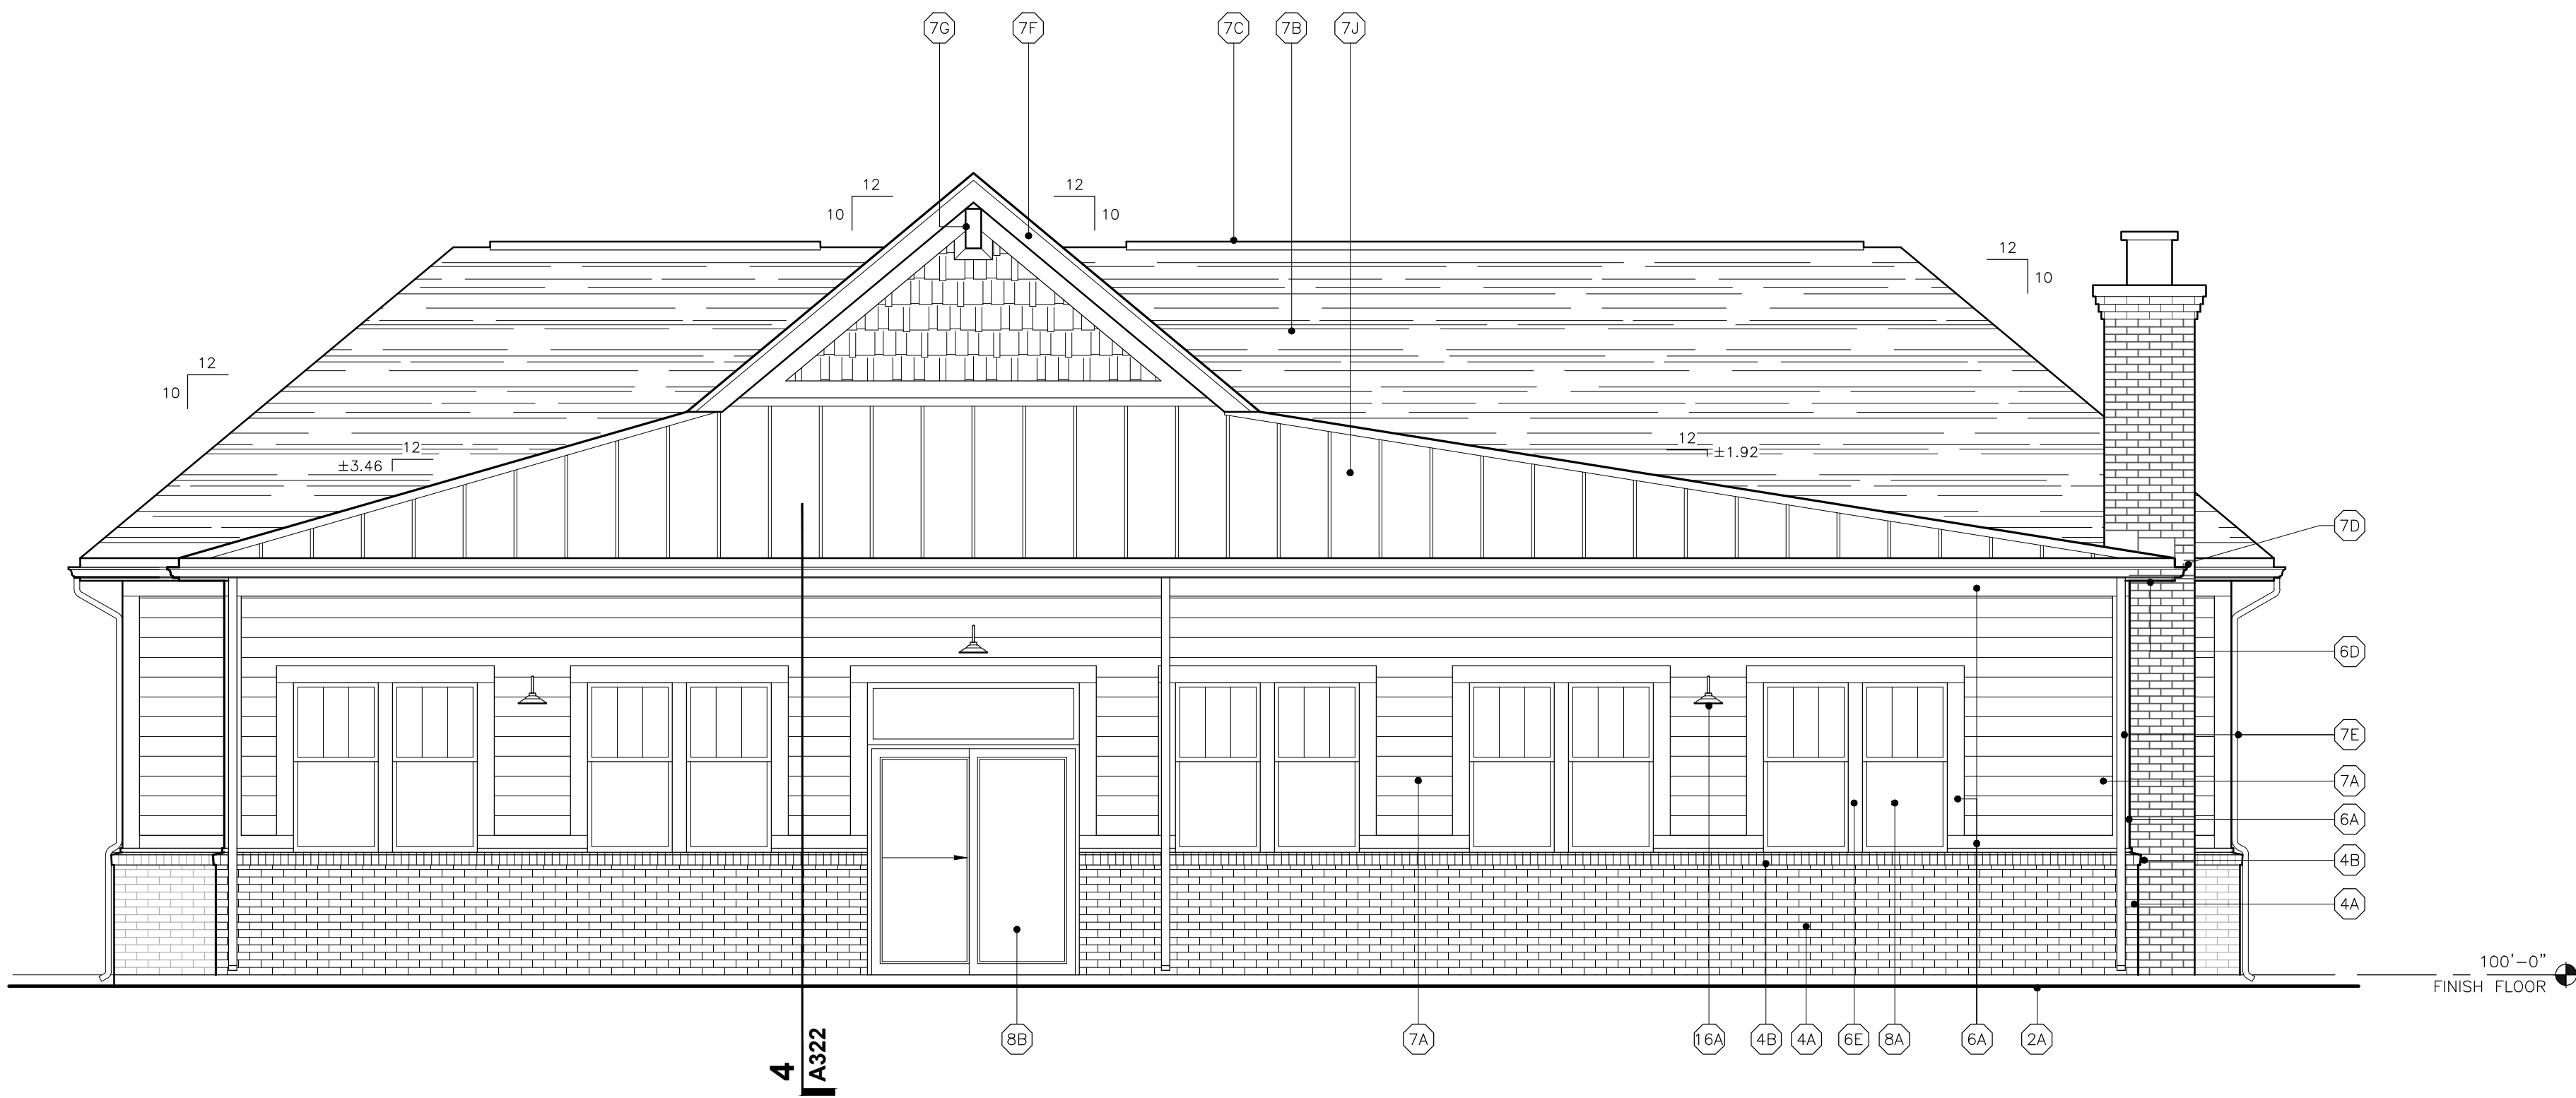

REAR ELEVATION
SCALE: 1/4"=1'-0"

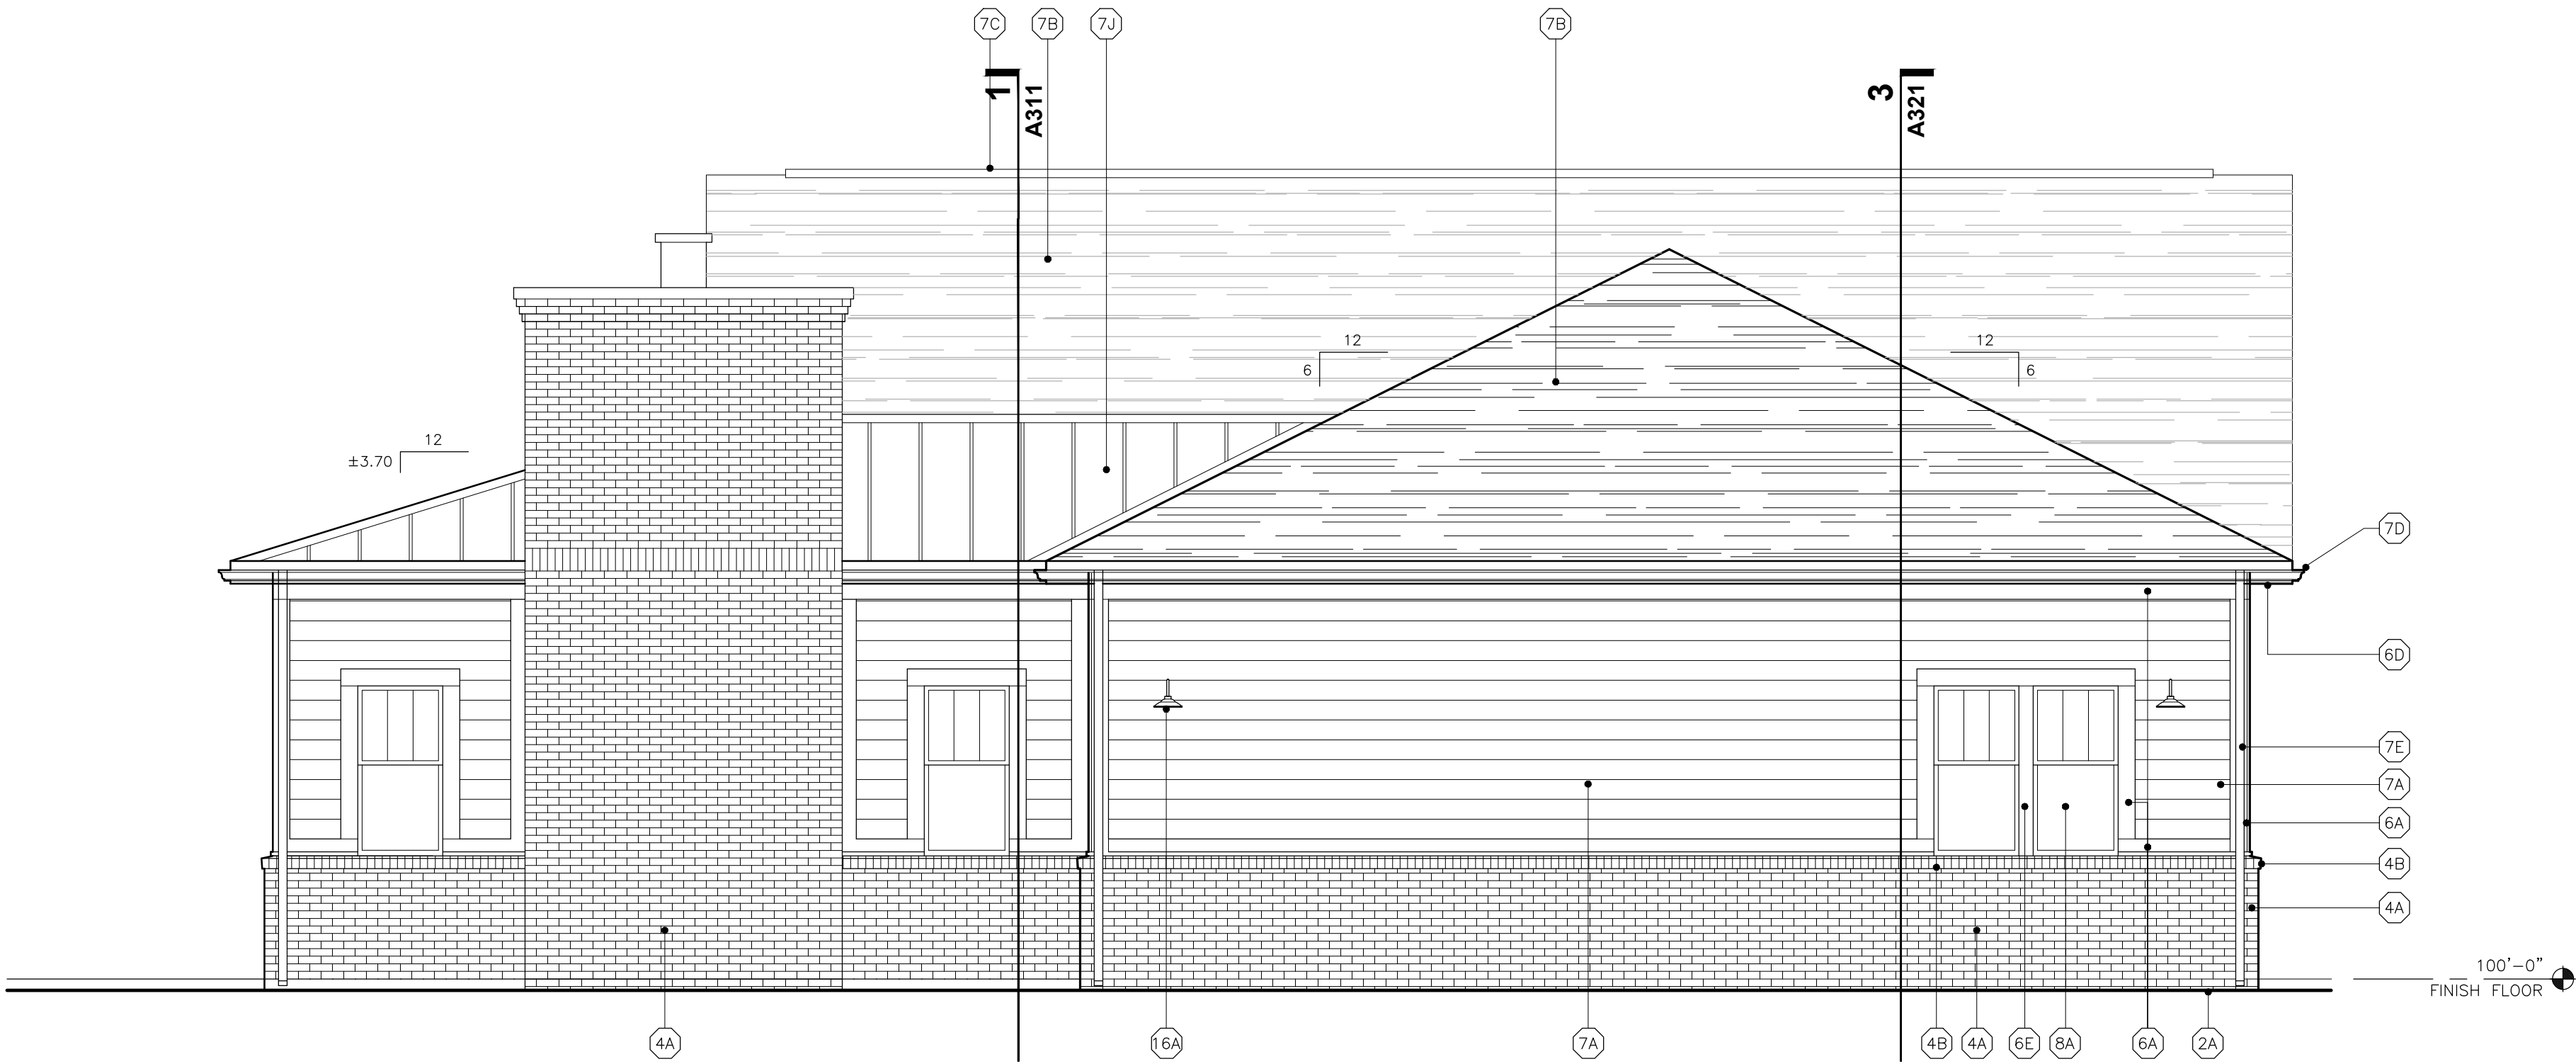

LEFT SIDE ELEVATION
SCALE: 1/4"=1'-0"

GENERAL NOTES:

G1. COORDINATE ALL PAINT & MATERIAL COLORS WITH OWNER PRIOR TO INSTALLATION AND/OR APPLICATION.

KEY NOTES:

- (2A) FINISH GRADE. SEE SITE PLANS
- (4A) BRICK VENEER
- (4B) BRICK SILL - ROWLOCK COURSE
- (6A) 5/4x6 LP SMARTTRIM, PAINTED
- (6B) ROUGH SAWN WOOD COLUMN, PAINTED. SEE ROOF FRAMING PLAN
- (6C) 5/4x8 AZEK BASE TRIM, PAINTED
- (6D) 4/4x6 LP SMARTTRIM FASCIA BOARD, PAINTED
- (6E) 5/4 LP SMARTTRIM, PAINTED
- (6F) 1x2 AZEK TRIM, PAINTED
- (7A) HARDIE COLORPLUS LAP SIDING W/ 7" EXPOSURE. FACTORY FINISH
- (7B) ASPHALT SHINGLES, GAF (TIMBERLINE HD2) ON RAPTOR SYNTHETIC UNDERLAYMENT ON ROOF SHEATHING ON ROOF TRUSSES. SEE STRUCTURAL
- (7C) CONTINUOUS RIDGE VENT
- (7D) PREFINISHED ALUMINUM GUTTER
- (7E) PREFINISHED ALUMINUM DOWNSPOUT
- (7F) 4/4 LP SMARTTRIM RAKE BOARD, PAINTED
- (7G) 5-1/2"x14" CEDAR OR FYPON DETAIL OR APPROVED EQUAL
- (7H) HARDIE COLORPLUS SHINGLE SIDING. FACTORY FINISH
- (7J) STANDING SEAM METAL ROOF SYSTEM ON RAPTOR SYNTHETIC UNDERLAYMENT ON ROOF SHEATHING ON ROOF TRUSSES. SEE STRUCTURAL
- (8A) WINDOW. SEE FLOOR PLAN
- (8B) DOOR. SEE FLOOR PLAN
- (15A) 12"x12" WALL LOUVER. SEE MECHANICAL PLANS
- (16A) WALL MOUNTED LIGHT FIXTURE. SEE ELECTRICAL PLANS

THE CONSTRUCTION DOCUMENTS ARE INSTRUMENTS OF SERVICE PREPARED BY BALAY ARCHITECTS, INC. FOR THE PROJECT DESCRIBED HEREIN. ANY REUSE OF THESE DOCUMENTS FOR ANY OTHER PROJECT WITHOUT THE WRITTEN CONSENT OF BALAY ARCHITECTS, INC. IS STRICTLY PROHIBITED. ANY REUSE OF THESE DOCUMENTS WITHOUT THE WRITTEN CONSENT OF BALAY ARCHITECTS, INC. SHALL BE AT THE USER'S SOLE RISK AND WITHOUT LIABILITY TO BALAY ARCHITECTS, INC. OR ANY OF ITS EMPLOYEES, AGENTS, OR REPRESENTATIVES.

A NEW FACILITY FOR
**MCCORD POINTE
AMENITY CENTER**

MCCORDSVILLE, INDIANA 46055

??

LENNAR

P R E L I M I N A R Y
NOT FOR CONSTRUCTION

indianapolis, indiana
Stillwater Minnesota

BALAY
ARCHITECTS

Michael E. Balay
Principal Architect
1000 North 10th Street
Indianapolis, Indiana 46208
Tel: (317) 590-7973
mike@balayarchitects.com

DWG. DATA	PROJECT NO.: 2101	DRAWN BY: ID	CHECKED BY: WEB	DESCRIPTION	
				INIT.	DATE
REV.	DATA	MARK	DATE	INIT.	DATE
		1	09/12/2022	WEB	
REV.	DATA	2			
		3			
REV.	DATA	4			
		5			
REV.	DATA	6			
		7			
REV.	DATA	8			
		9			

© 2021 BALAY ARCHITECTS, INC.

EXTERIOR
ELEVATIONS

A212



A121